


- CURRENT APPLICATION/ SCOPE OF WORKS
- FUTURE HARDSTANDING WORKS
- FUTURE BUILDING WORKS

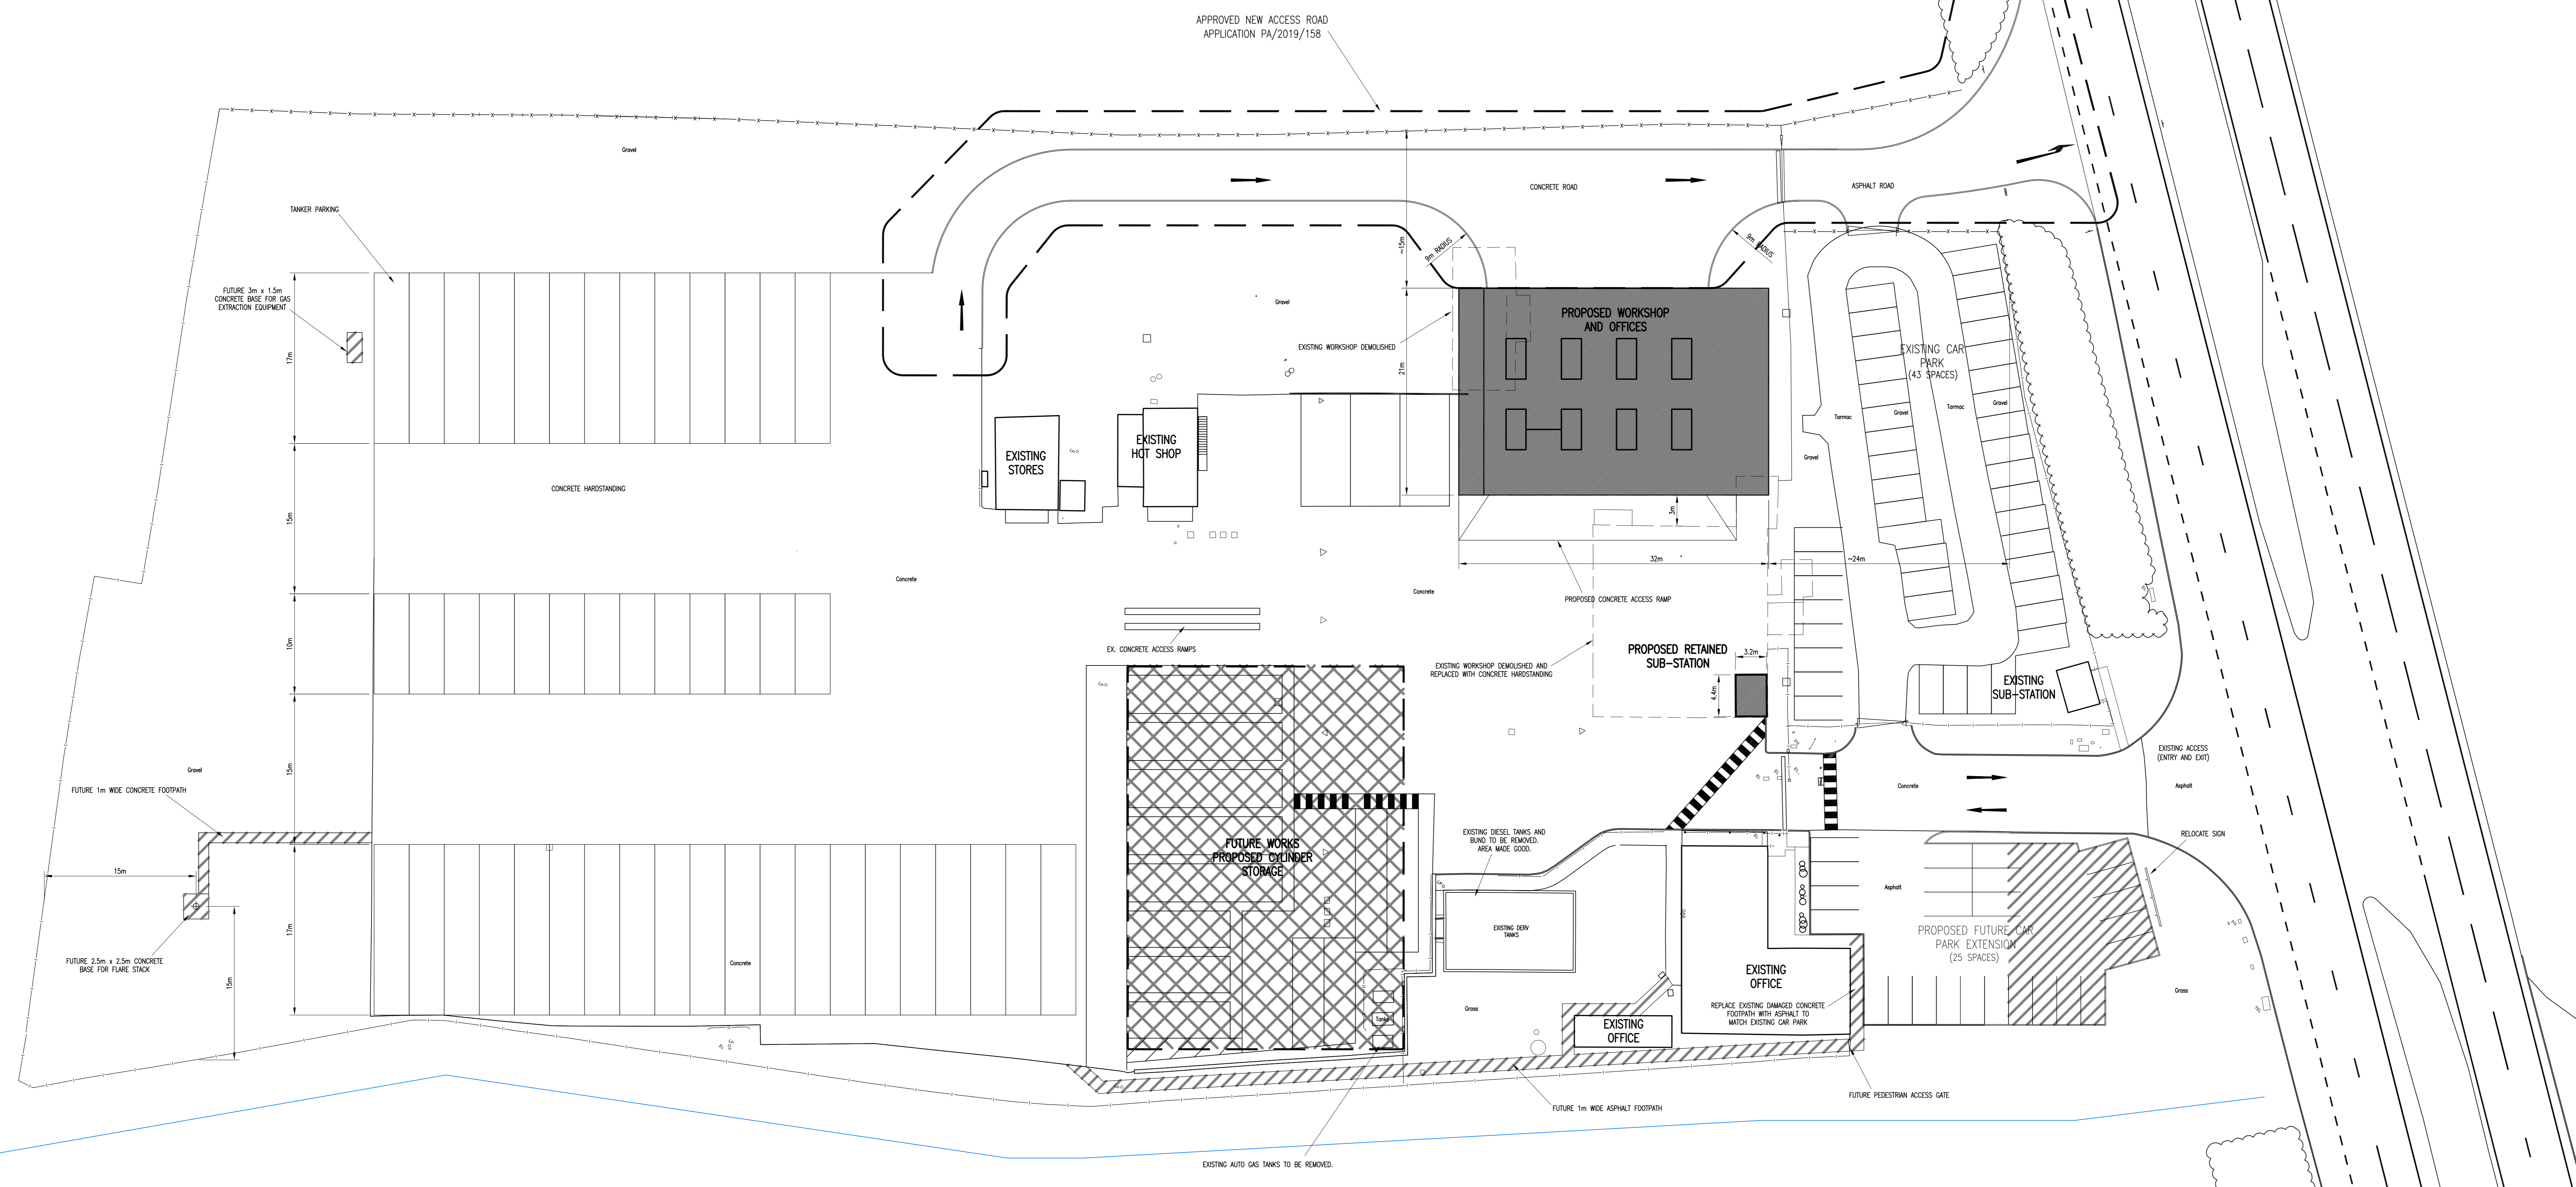

PROPOSED SITE LAYOUT

- NOTES**
1. ALL WORK TO BE IN ACCORDANCE WITH ALL RELEVANT BRITISH STANDARD SPECIFICATIONS, CODES OF PRACTICE AND ENGINEER'S SPECIFICATIONS.
  2. THIS DRAWING TO BE READ IN CONJUNCTION WITH ALL RELEVANT ARCHITECTURAL AND ENGINEERING SERVICES DRAWINGS, INC. CLIENT'S SPEC.
  3. ALL DIMENSIONS TO BE CHECKED ON SITE BY THE CONTRACTOR PRIOR TO FABRICATION.
  4. IN CASE OF DISCREPANCY BETWEEN DRAWINGS, OR A LACK OF DIMENSIONS, MGA LTD MUST BE CONSULTED BEFORE WORK PROCEEDS.
  5. DO NOT SCALE THIS DRAWING. IF IN DOUBT ASK.
  6. FFL DENOTES FINISHED FLOOR LEVEL.  
TOF DENOTES TOP OF FOUNDATION LEVEL.  
GL DENOTES GROUND LEVEL.
  7. ALL DIMENSIONS SHOWN ARE IN MILLIMETRES.
  8. ALL LEVELS SHOWN ARE IN METRES.


P1	INITIAL ISSUE	16.04.19	AB
REV	DESCRIPTION	DATE	BY

**STATUS** PLANNING

**PROJECT**  
 WORKSHOP RELOCATION.  
 CALOR GAS LTD.  
 MANBY RD, SOUTH KILLINGHOLME,  
 IMMINGHAM, DN40 3DX.

**TITLE**  
 PROPOSED PHASE 2 SITE PLAN

**McGREGOR ASSOCIATES LTD**  
 CONSULTING CIVIL AND STRUCTURAL ENGINEERS  
 & BUILDING DESIGN CONSULTANTS

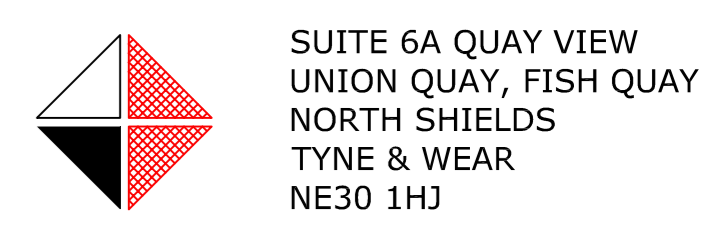

SUITE 6A QUAY VIEW  
 UNION QUAY, FISH QUAY  
 NORTH SHIELDS  
 TYNE & WEAR  
 NE30 1HJ

TEL: 0191 2592300  
 E-MAIL: info@mcgregorassociates.co.uk

DATE	SCALE	DRAWN	CHECKED	APPRV.
APR' 2019	1:250	AB	SH	
JOB NUMBER	DRAWING NUMBER	REV	SIZE	
5/3592	05	P1	A0	