


Symbol	Label	Quantity	Catalog Number	Description	Lumens Per Lamp	Wattage
	A	14	DSX2.2.LA364.FW	D-Series 2 Luminaire	40787	328
	B	3	BCL.1.LA404.SY	CityMax Large	43355	290
	C	2	DSX1.2.LA114.AY	D-Series 1 Luminaire	12214	105

Statistics					
Description	Symbol	Avg	Min	Max	Min/Avg
Car Park	+	20 lux	11 lux	0.55	
Lorry Park	+	27 lux	11 lux	0.41	
Spill Calcs	+	3 lux	0 lux	0.00	

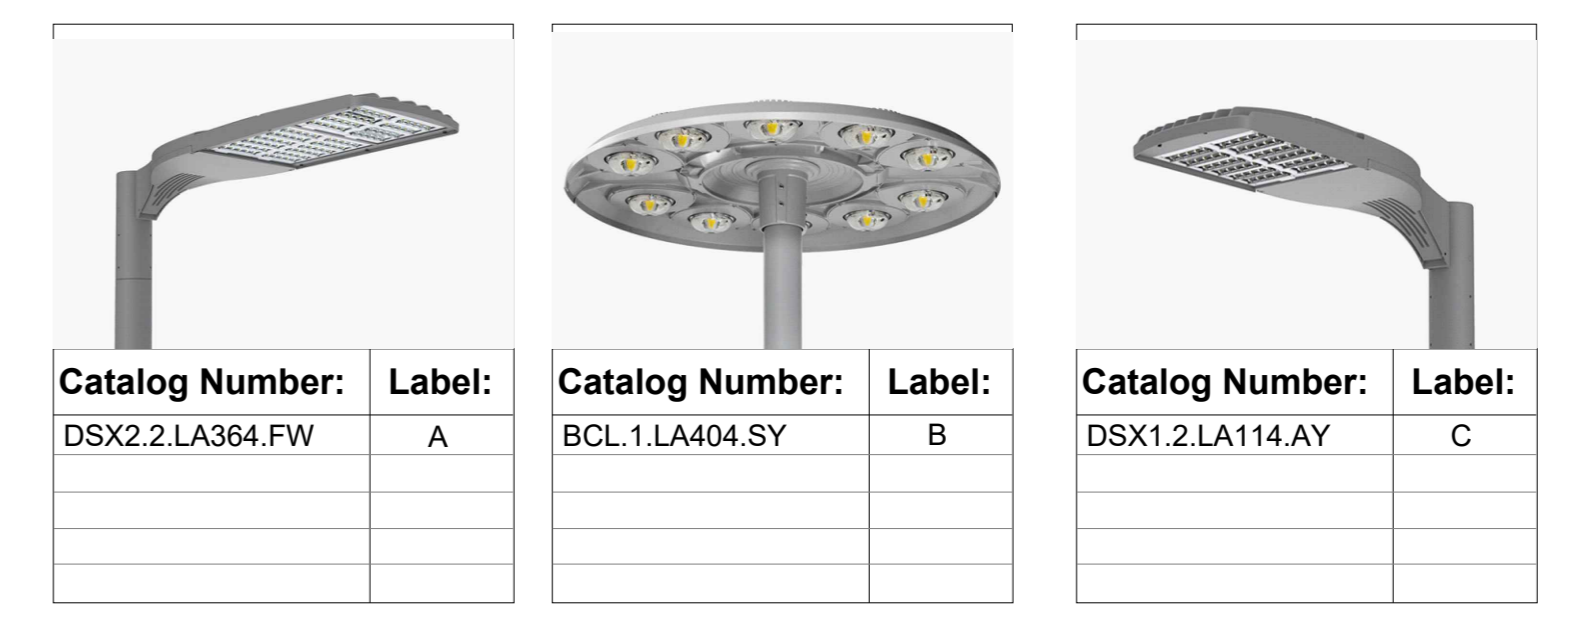

The copyright of this document is vested solely in Kelly Taylor & Associates.

Reproduction of this document, in whole or in part, is prohibited other than with the express permission of the above company.

This drawing to be read in conjunction with all relevant architect, consultant, sub-contractors and specialist drawings, and should not be scaled from in any way.

Revisions

Rev	By	Date	Description	Chk
A	CA	19.11.21	Descriptor Amended with latest lux level lighting plan.	MJP

Client

Wren Kitchens

Architect

BE Design

Project Address

Wren Kitchens
Falkland Way
Barton upon Humber

Drawing Title

External Lighting
Lux Layout

Project Address

Wren Kitchens
Falkland Way
Barton upon Humber

Drawing Title

External Lighting
Lux Layout

Project Address

Wren Kitchens
Falkland Way
Barton upon Humber

Drawing Title

External Lighting
Lux Layout

Project Address

Wren Kitchens
Falkland Way
Barton upon Humber

Drawing Title

External Lighting
Lux Layout

Project Address

Wren Kitchens
Falkland Way
Barton upon Humber

Drawing Title

External Lighting
Lux Layout

Project Address

Wren Kitchens
Falkland Way
Barton upon Humber

Drawing Title

External Lighting
Lux Layout

Project Address

Wren Kitchens
Falkland Way
Barton upon Humber

Drawing Title

External Lighting
Lux Layout

Project Address

Wren Kitchens
Falkland Way
Barton upon Humber

Drawing Title

External Lighting
Lux Layout

Project Address

Wren Kitchens
Falkland Way
Barton upon Humber

Drawing Title

External Lighting
Lux Layout

Project Address

Wren Kitchens
Falkland Way
Barton upon Humber

Drawing Title

External Lighting
Lux Layout

Project Address

Wren Kitchens
Falkland Way
Barton upon Humber

Drawing Title

External Lighting
Lux Layout

Project Address

Wren Kitchens
Falkland Way
Barton upon Humber

Drawing Title

External Lighting
Lux Layout



KELLY TAYLOR & ASSOCIATES
ENGINEERING & ENVIRONMENTAL CONSULTANTS
1 ASHLEIGH WAY, LANGAGE BUSINESS PARK,
PLYMOUTH, DEVON, PL7 5JX.
TEL: +44(0)1752 332890 FAX: +44(0)1752 344282
E-MAIL: general@kellytaylor.net

PLANNING

Drawn by: CA, Checked by: MJP, Authorised by: MJP

Scale: 1:250, Size: A0, Date: Nov '21

Drawing no.: 104501-EXT-01, Rev: A