

ROOF LEVEL PLAN
SCALE - 1:100



- NOTES:-**
- ALL DIMENSIONS ARE IN MILLIMETRES AND LEVELS ARE IN METRES UNLESS NOTED OTHERWISE.
 - EL +100.000 CORRESPONDS TO FINISH GROUND LEVEL AT RESPECTIVE PLOT PLAN DRAWING NO. 415000-00201-8230-01-0002.
 - FOR BUILDING LOCATION AND SITE DATUM REFER TO SITE PLAN DRG. NO. 415000-00201-8230-01-0002.
 - ALL STRUCTURAL ARRANGEMENT SHOWN ARE INDICATIVE, CONTRACTOR SHALL ENSURE DESIGN AND CONSTRUCTION OF BUILDING IN ACCORDANCE WITH STRUCTURAL DRAWINGS.

- LEGEND**
- EL ELEVATION
 - RWP RAIN WATER PIPE
 - UNO UNLESS NOTED OTHERWISE

HOLD LIST

-

KEY PLAN

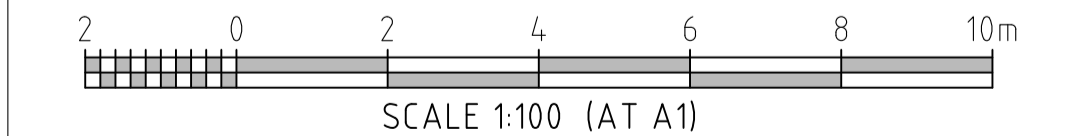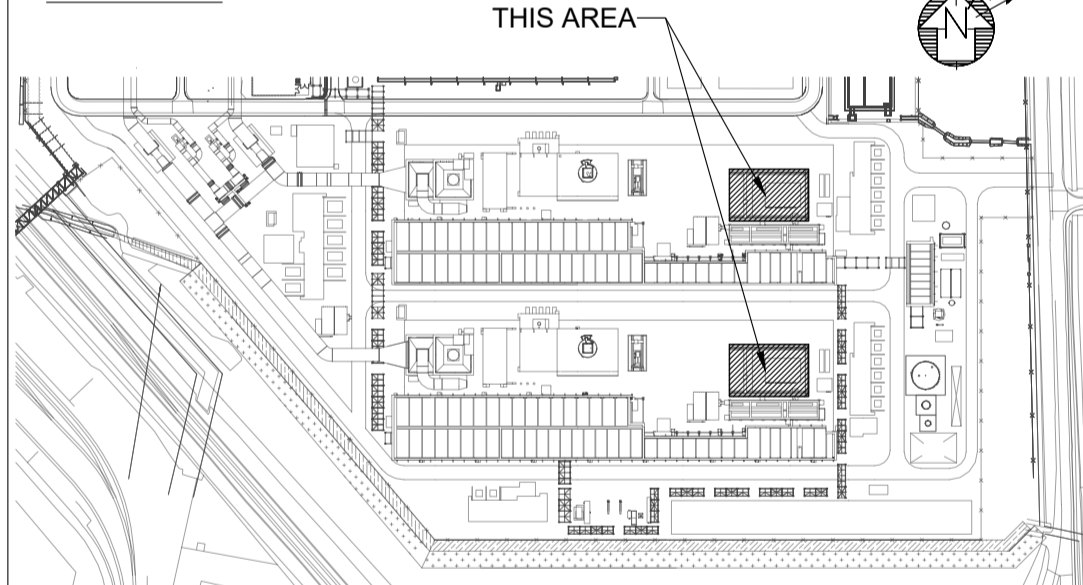

REV	DATE	REVISION DESCRIPTION	DRAWN	DRAFT CHK	DESIGNED	ENG CHK	APPROVED	REF DRAWING No	REFERENCE DRAWING TITLE
0	08/02/23	ISSUED FOR DESIGN	RAWK	NAKA	JOSA	SB	PBA	415000-00201-8530-78-0002	OVERALL PRELIMINARY CABLE TRAY LAYOUT
C	12/01/23	RE-ISSUED FOR REVIEW	RAWK	NAKA	JOSA	SB	PBA	415000-00201-8340-48-0009	HVAC D&ID - CO2 COMPRESSOR HOUSE TRAIN 1, TRAIN 2
B	02/12/22	ISSUED FOR REVIEW	RAWK	NAKA	JOSA	SB	PBA	415000-00201-8540-80-0018-01	HVAC GENERAL ARRANGEMENT - CO2 COMPRESSOR HOUSE TRAIN 1, TRAIN 2
A	07/11/22	ISSUED FOR IDC	RAWK	NAKA	JOSA	PBA	AG	415000-00201-8330-47-0008	TELECOM & SECURITY EQUIPMENT LAYOUT-COMPRESSOR HOUSE
								415000-00201-8330-47-0009	CO2 COMPRESSOR HOUSE 01A/01B (30-BD-1709/1710) ARCHITECTURAL SECTIONS
								415000-00201-8330-47-0008	CO2 COMPRESSOR HOUSE 01A/01B (30-BD-1709/1710) ARCHITECTURAL ELEVATIONS
								415000-00201-8330-47-0005	CO2 COMPRESSOR HOUSE 01A/01B (30-BD-1709/1710) ARCHITECTURAL GROUND FLOOR PLAN

A1 SHEET SCALE 1:100

WORLEY PROJECT No
415000-00201

ENGINEERING AND PERMIT STAMPS (As Required)

CUSTOMER

"This drawing is prepared solely for the use of the contractual customer of Worley and Worley assumes no liability to any other party for any representations contained in this drawing."

DRG TITLE	HZ VPI-PCC PROJECT CO2 COMPRESSOR HOUSE (30-BD-1709/2710) ARCHITECTURAL ROOF LEVEL PLAN
DRG No	415000-00201-8330-47-0007
REV	0

LOCATION: C:\USERS\KRISHNAJI\RAWOL\WORLEY\NUMBER ZERO VPI-IMMINGHAM POST - COMBUSTION CARBON CAPTURE PROJECT FEED - DOCUMENTS\10 ENG\07 CIVIL\15 DWGS\FROM GD\01 ARCH DRAWINGS\01 WORKING\04 COMPRESSOR HOUSE RE FR-19072023\415000-00201-8330-47-0007
 USER NAME: krishna.jirawol
 PLOT DATE & TIME: 8/2/2023 4:41:06 PM
 SAVE DATE & TIME: 8/2/2023 4:37:20 PM
 Worley_A1