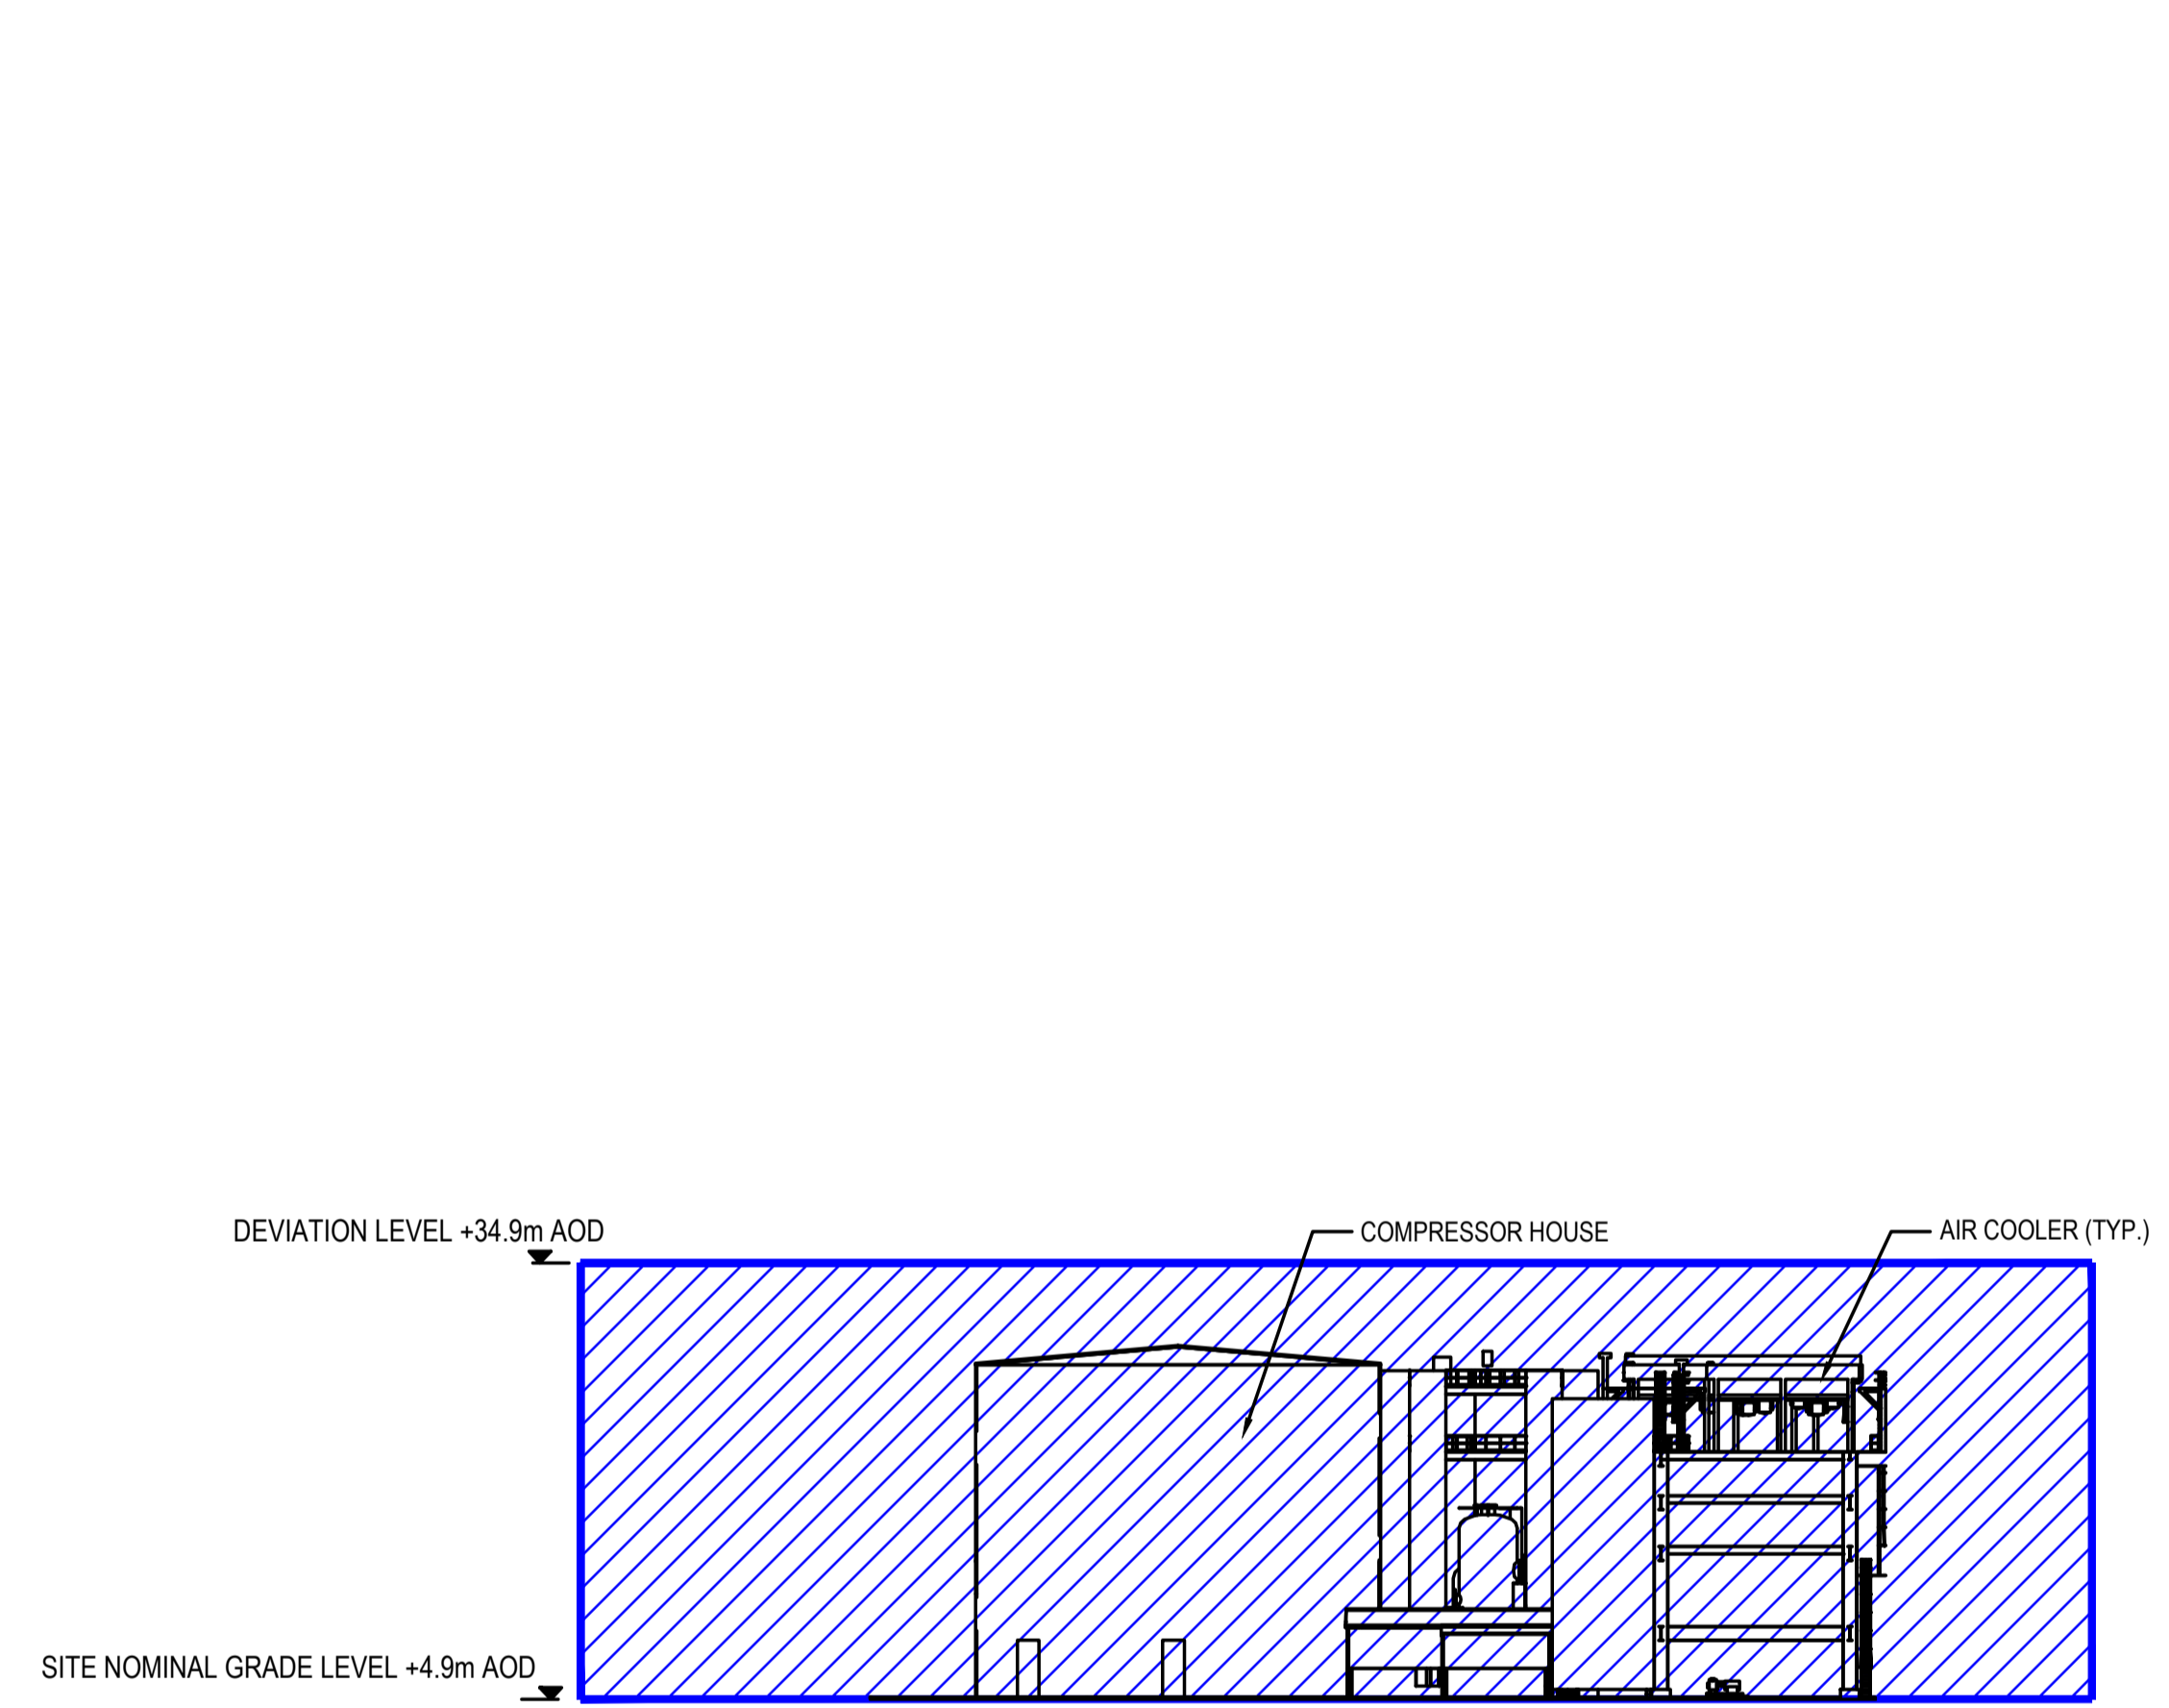
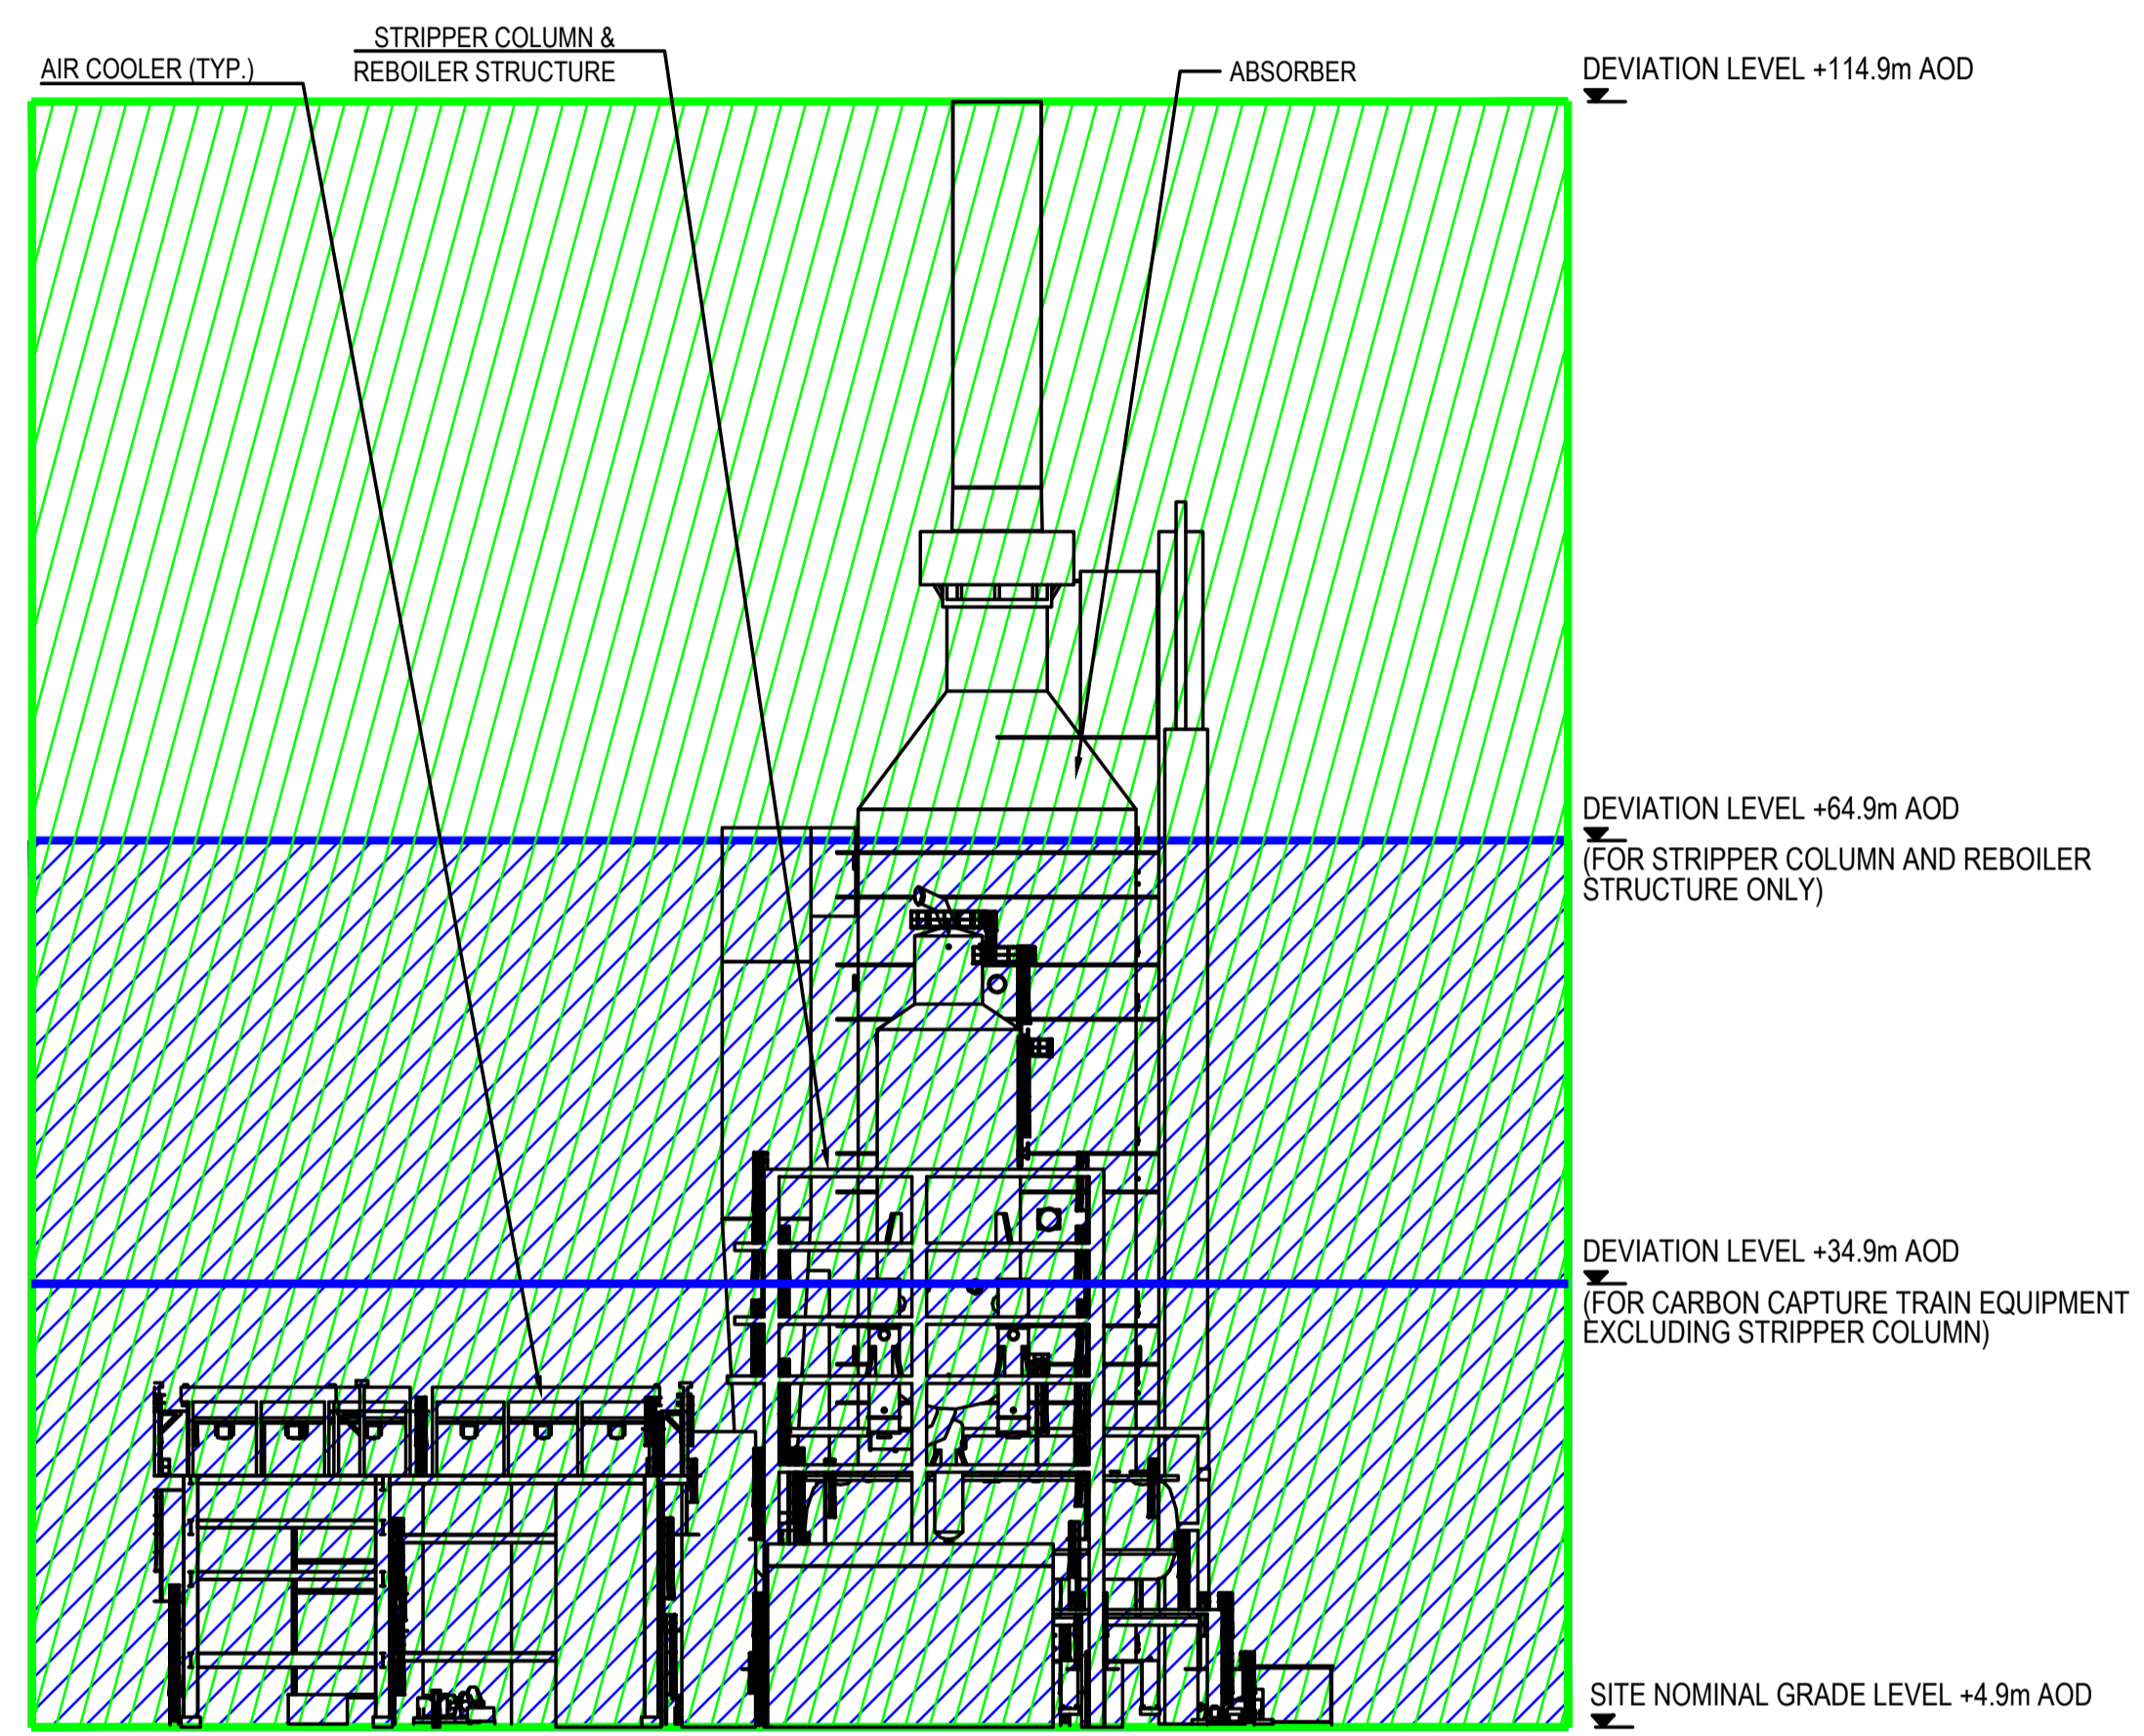


 

NOTES:
 1. DRAWING IS FOR PLANNING PURPOSES ONLY.
 2. MINOR CABLE / PIPELINE CONNECTIONS ABOVE AND BELOW GROUND (BUT NOT OVERHEAD) ARE NOT SHOWN.






SECTION LOOKING EAST ON 'N-N'



SECTION LOOKING WEST ON 'P-P'

KEY
 CARBON CAPTURE PLANT
 FLUE GAS HANDLING



									A1 SHT	SCALE: 1:500	ENGINEERING AND PERMIT STAMPS (As Required)	CUSTOMER	DRG TITLE			
											 	HZ-VPI-1 PCC PROJECT VERTICAL PARAMETER / ZONING PLANNING DRAWING SECTIONS - SHEET 3				
1	15/02/23	FOR USE	NG	CFT	NG	CFT	AG	415000-00201-8820-01-0001						HZ-VPI-1 PCC PROJECT - PARAMETER / ZONING PLANNING DRAWING - KEY PLAN		
0	03/02/23	FOR USE	NG	CFT	NG	CFT	AG	415000-00201-8230-01-0002	HZ-VPI-1 PCC PROJECT - PLOT PLAN							
A	04/10/22	FOR REVIEW	NG	CFT	NG	CFT	AG	415000-00201-8230-01-0001	HZ-VPI-1 PCC PROJECT - SITE PLAN							
REV	DATE	PURPOSE	DRAWN	DRAFT CHK	DESIGNED	ENG CHK	APPROVED	REF DRAWING No	REFERENCE DRAWING TITLE	WORLEY PROJECT No.	<small>*This drawing is prepared solely for the use of the contractual customer of Worley and Worley assumes no liability to any other party for any representations contained in this drawing.*</small>		DRG No	415000-00201-8820-01-0016	REV	1