


SECTION LOOKING NORTH ON 'Q-Q'

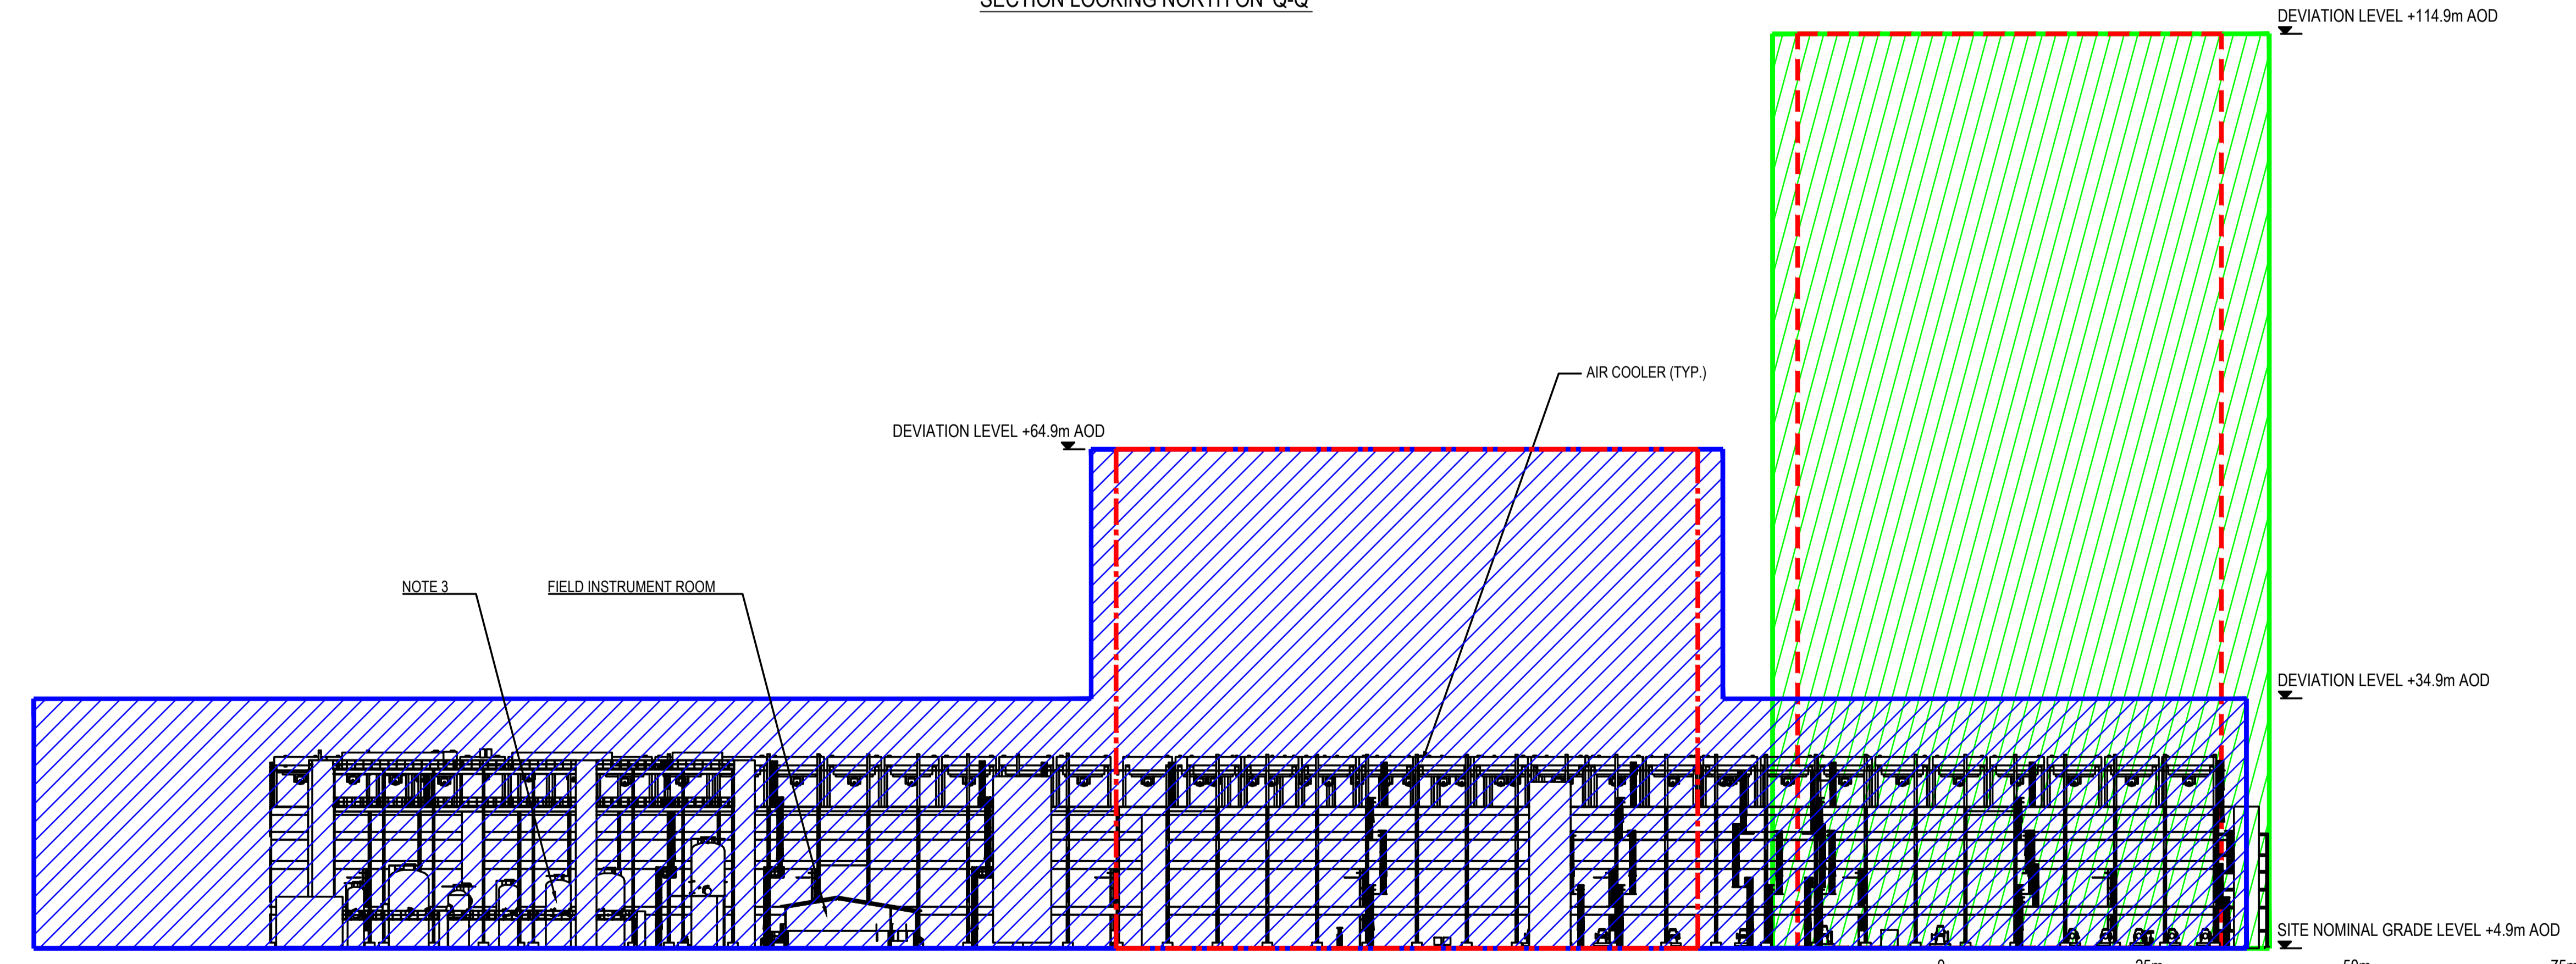

SECTION LOOKING SOUTH ON 'R-R'



- NOTES:**
1. DRAWING IS FOR PLANNING PURPOSES ONLY.
 2. MINOR CABLE / PIPELINE CONNECTIONS ABOVE AND BELOW GROUND (BUT NOT OVERHEAD) ARE NOT SHOWN.
 3. COMPRESSOR HOUSE OMITTED TO SHOW DETAIL OF KO DRUMS.

- KEY**
- CARBON CAPTURE PLANT
 - FLUE GAS HANDLING
 - ABSORBER TOWER LIMITS OF DEVIATION WITHIN CC PLANT
 - STRIPPER COLUMN LIMITS OF DEVIATION WITHIN CC PLANT

REV	DATE	PURPOSE	DRAWN	DRAFT	CHK	DESIGNED	ENG	CHK	APPROVED	REF DRAWING No	REFERENCE DRAWING TITLE
1	15/02/23	FOR USE	NG	CFT	NG	CFT	AG			415000-00201-8820-01-0001	HZ-VPI-PCC PROJECT - PARAMETER / ZONING PLANNING DRAWING - KEY PLAN
0	03/02/23	FOR USE	NG	CFT	NG	CFT	AG			415000-00201-8230-01-0002	HZ-VPI-PCC PROJECT - PLOT PLAN
A	04/10/22	FOR REVIEW	NG	CFT	NG	CFT	AG			415000-00201-8230-01-0001	HZ-VPI-PCC PROJECT - SITE PLAN

A1 SHT SCALE: 1:500

ENGINEERING AND PERMIT STAMPS (As Required)

Worley
energychemicalresources

WORLEY PROJECT No.
415000-00201

CUSTOMER

HUMBERZERO

VPI mingham

This drawing is prepared solely for the use of the contractual customer of Worley and Worley assumes no liability to any other party for any representations contained in this drawing.

DRG TITLE

HZ-VPI-PCC PROJECT
VERTICAL PARAMETER / ZONING PLANNING DRAWING
SECTIONS - SHEET 4

DRG No 415000-00201-8820-01-0017

REV 1