
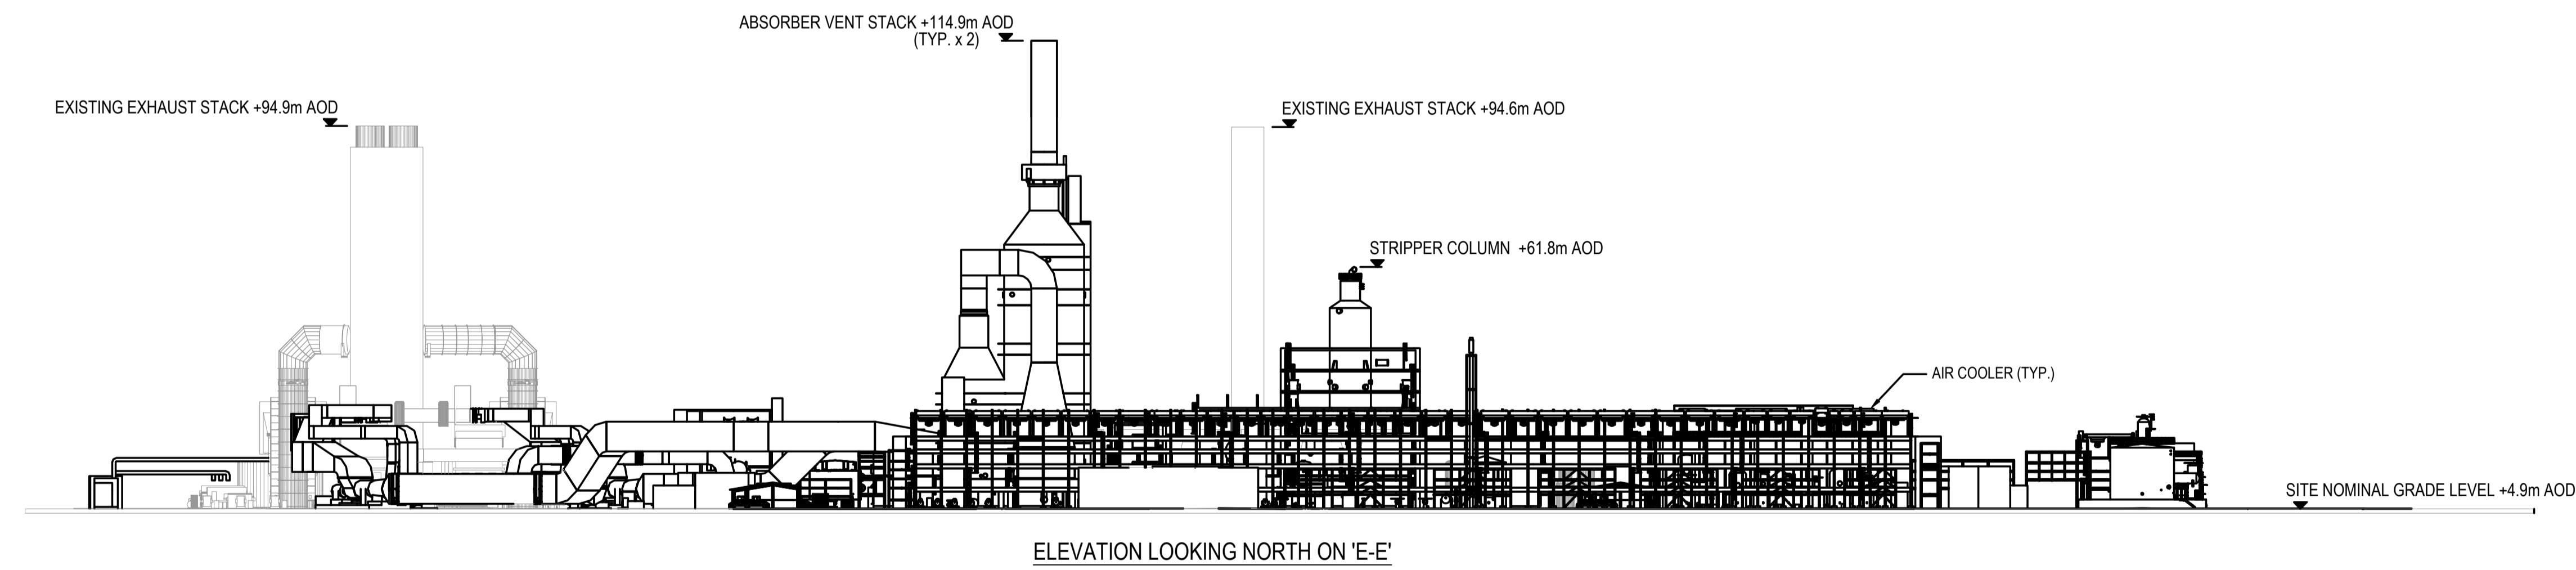


NOTES:
 1. DRAWING IS FOR PLANNING PURPOSES ONLY.
 2. MINOR CABLE / PIPELINE CONNECTIONS ABOVE AND BELOW GROUND (BUT NOT OVERHEAD) ARE NOT SHOWN.
 3. NEW EQUIPMENT ELEVATIONS STATED INDICATE MAXIMUM VALUES.

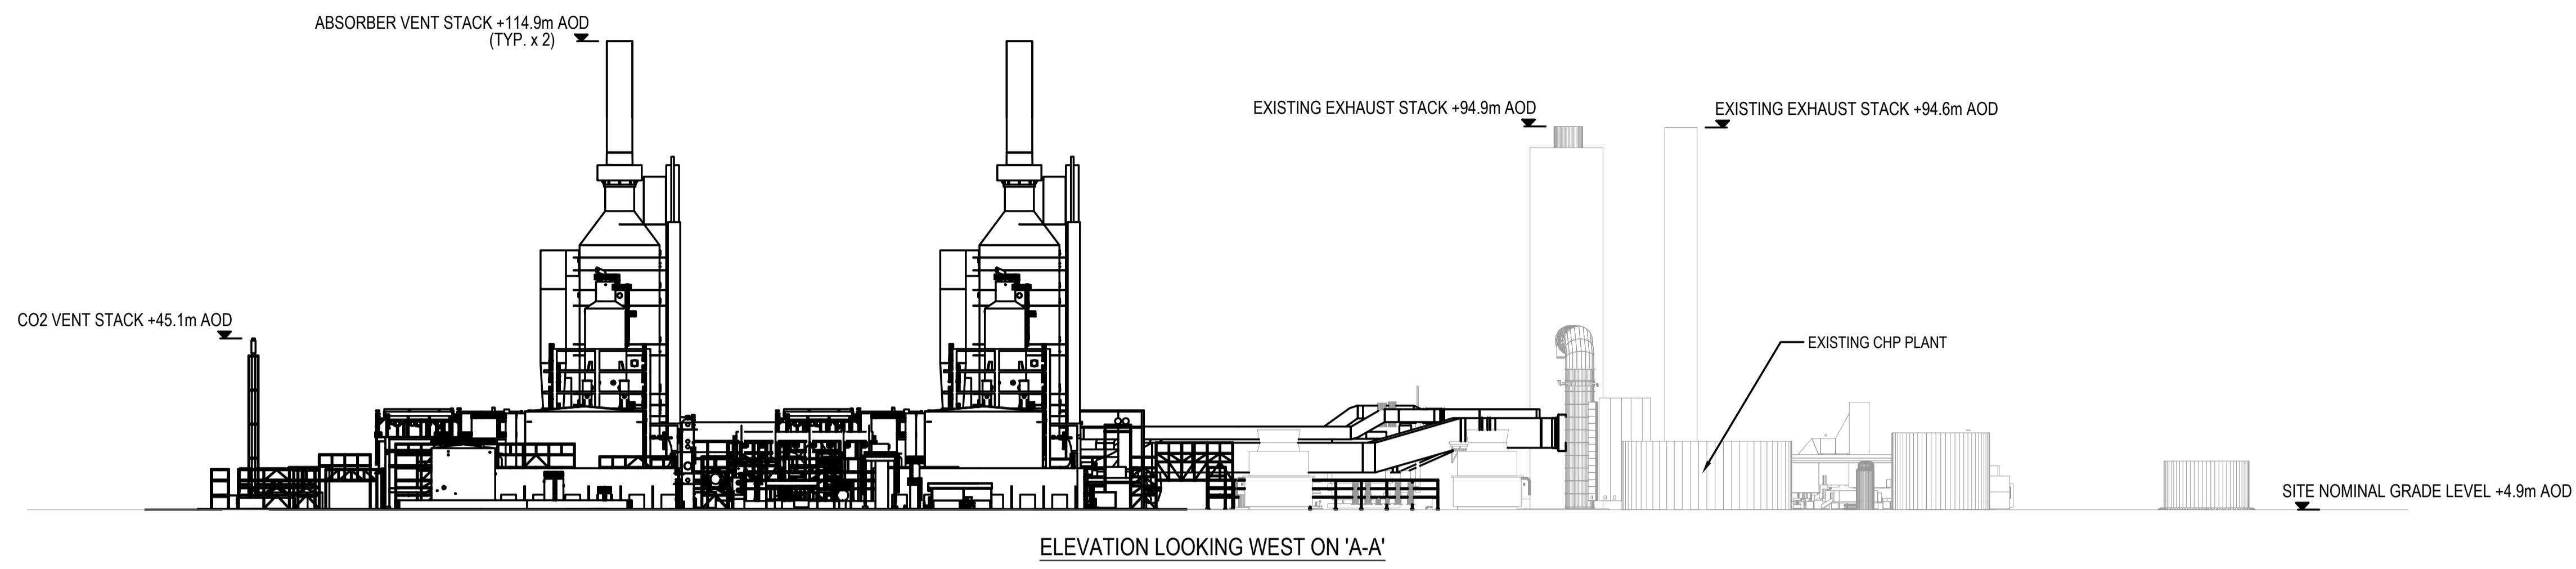

								A1 SHT	SCALE: 1:1000	ENGINEERING AND PERMIT STAMPS (As Required)	CUSTOMER	DRG TITLE	
											 	HZ-VPI-1 PCC PROJECT PROPOSED GENERAL ARRANGEMENT ELEVATIONS - SHEET 1	
1	15/02/23	FOR USE	NG	CFT	NG	CFT	AG						415000-00201-8820-01-0004
0	03/02/23	FOR USE	NG	CFT	NG	CFT	AG	415000-00201-8230-01-0002	HZ-VPI PCC PROJECT - PLOT PLAN				
A	04/10/22	FOR REVIEW	NG	CFT	NG	CFT	AG	415000-00201-8230-01-0001	HZ-VPI PCC PROJECT - SITE PLAN				
REV	DATE	PURPOSE	DRAWN	DRAFT CHK	DESIGNED	ENG CHK	APPROVED	REF DRAWING No	REFERENCE DRAWING TITLE	WORLEY PROJECT No.	<small>*This drawing is prepared solely for the use of the contractual customer of Worley and Worley assumes no liability to any other party for any representations contained in this drawing.*</small>	DRG No	REV
										415000-00201		415000-00201-8820-01-0011	1