



NOTES:


1. DRAWING IS FOR PLANNING PURPOSES ONLY.
2. MINOR CABLE / PIPELINE CONNECTIONS ABOVE AND BELOW GROUND (BUT NOT OVERHEAD) ARE NOT SHOWN.
3. NEW EQUIPMENT ELEVATIONS STATED INDICATE MAXIMUM VALUES.

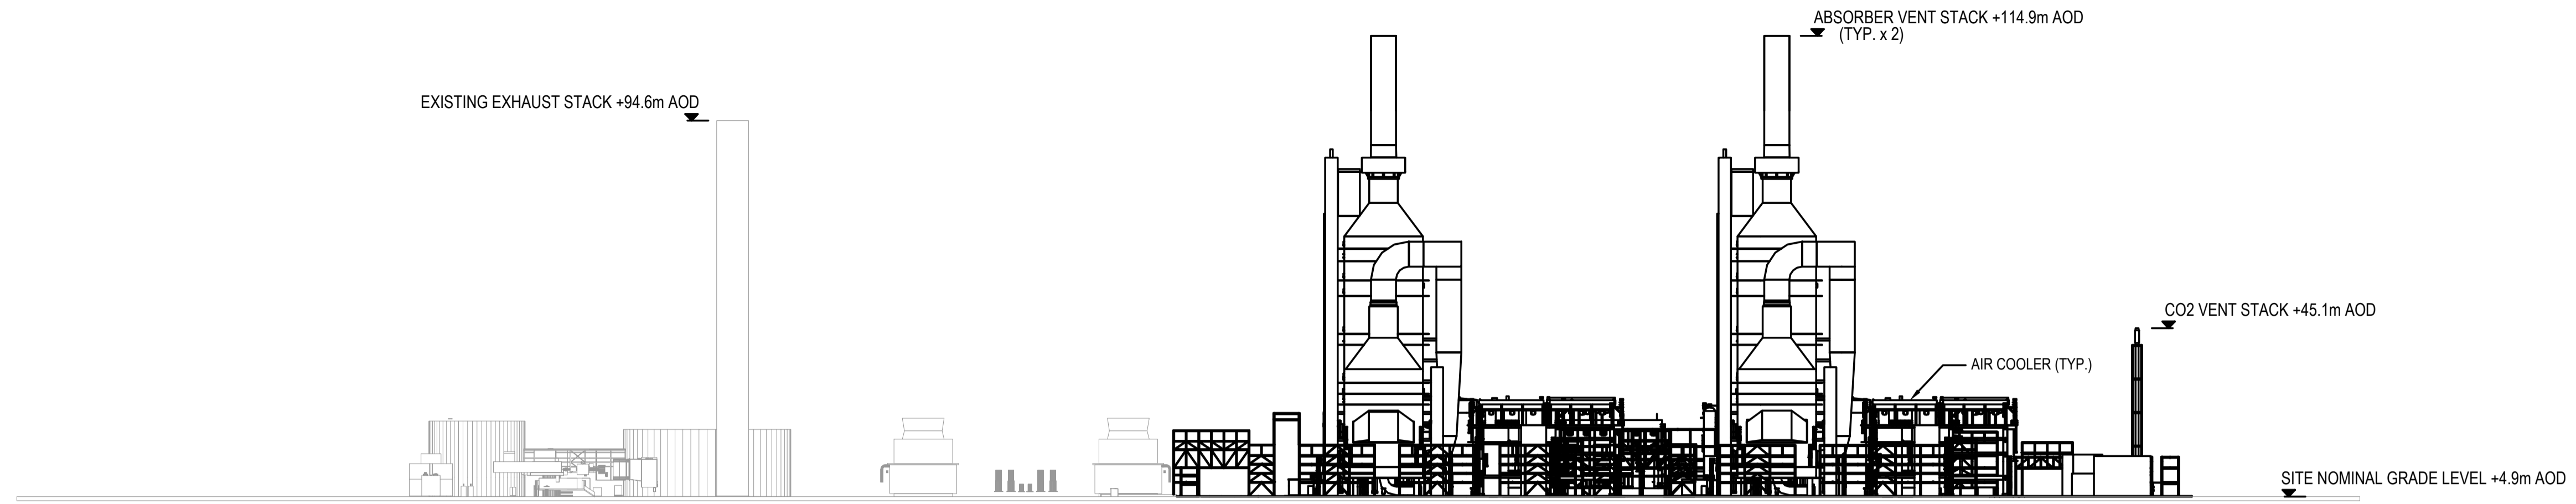

ELEVATION LOOKING EAST ON 'F-F'

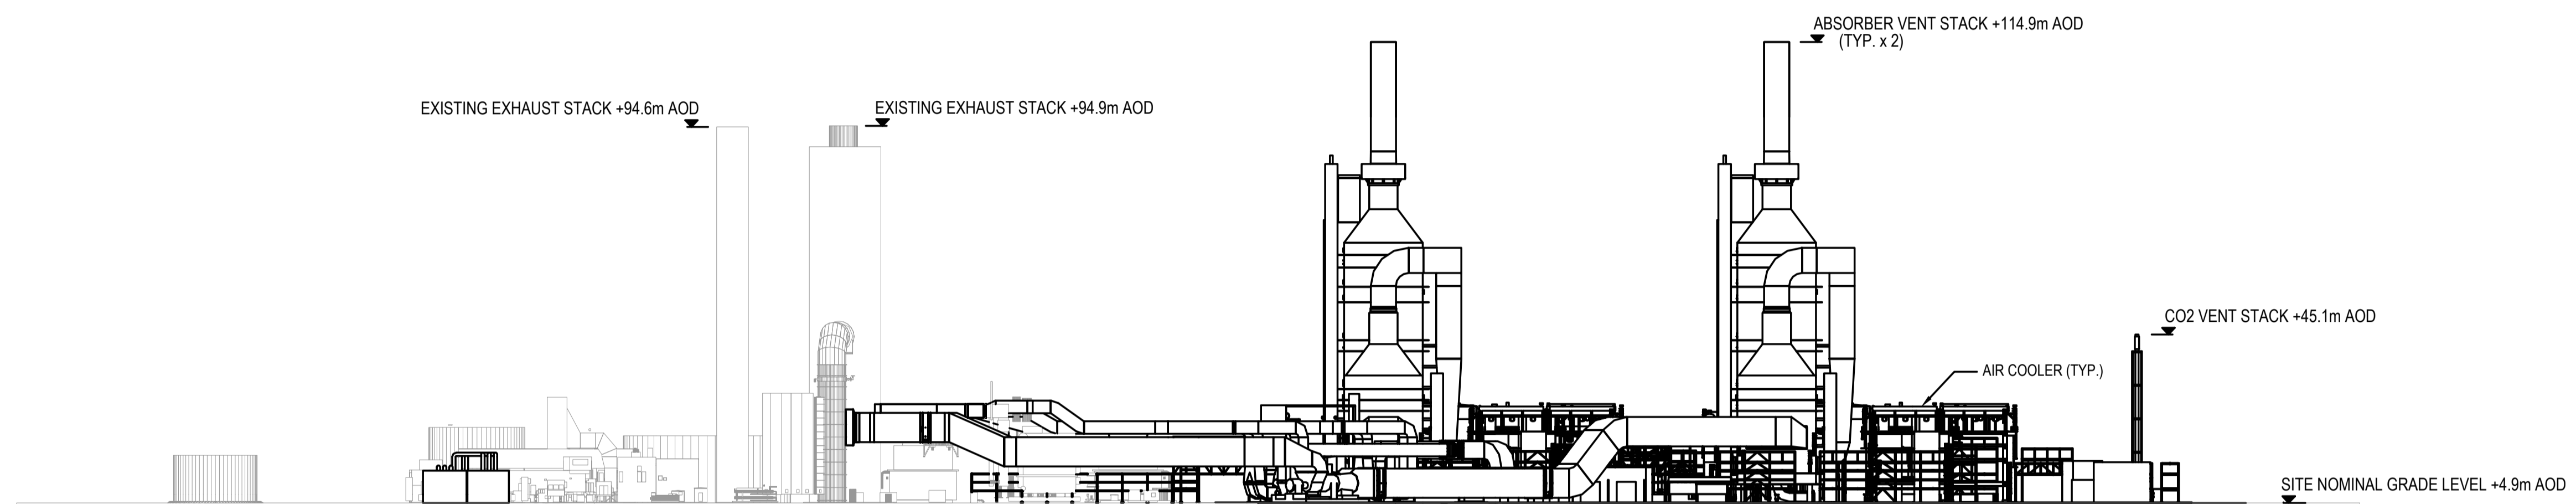

ELEVATION LOOKING EAST ON 'B-B'

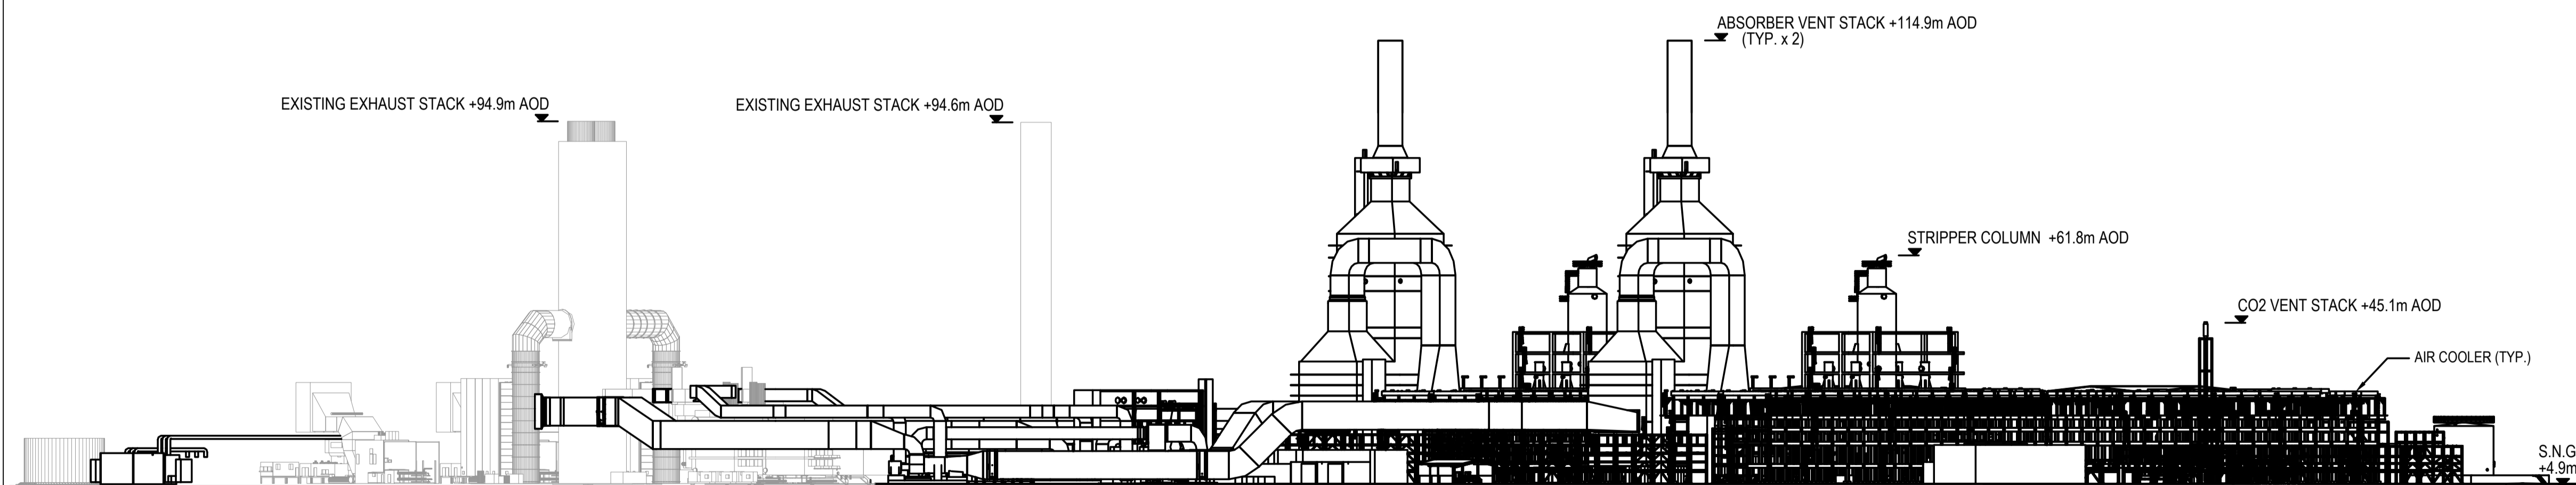

ELEVATION LOOKING EAST 40.171° NORTH ON 'C-C'



								A1 SHT	SCALE: 1:1000	ENGINEERING AND PERMIT STAMPS (As Required)	CUSTOMER	DRG TITLE		
										 		HZ-VPI-I PCC PROJECT PROPOSED GENERAL ARRANGEMENT ELEVATIONS - SHEET 2		
														WORLEY PROJECT No. 415000-00201
1	15/02/23	FOR USE	NG	CFT	NG	CFT	AG	415000-00201-8820-01-0004	HZ-VPI-I PCC PROJECT - PROPOSED GENERAL ARRANGEMENT - KEY PLAN					
0	03/02/23	FOR USE	NG	CFT	NG	CFT	AG	415000-00201-8230-01-0002	HZ-VPI-I PCC PROJECT - PLOT PLAN					
A	04/10/22	FOR REVIEW	NG	CFT	NG	CFT	AG	415000-00201-8230-01-0001	HZ-VPI-I PCC PROJECT - SITE PLAN					
REV	DATE	PURPOSE	DRAWN	DRAFT CHK	DESIGNED	ENG CHK	APPROVED	REF DRAWING No	REFERENCE DRAWING TITLE					
											DRG No	415000-00201-8820-01-0012	REV	1

This drawing is prepared solely for the use of the contractual customer of Worley and Worley assumes no liability to any other party for any representations contained in this drawing.