


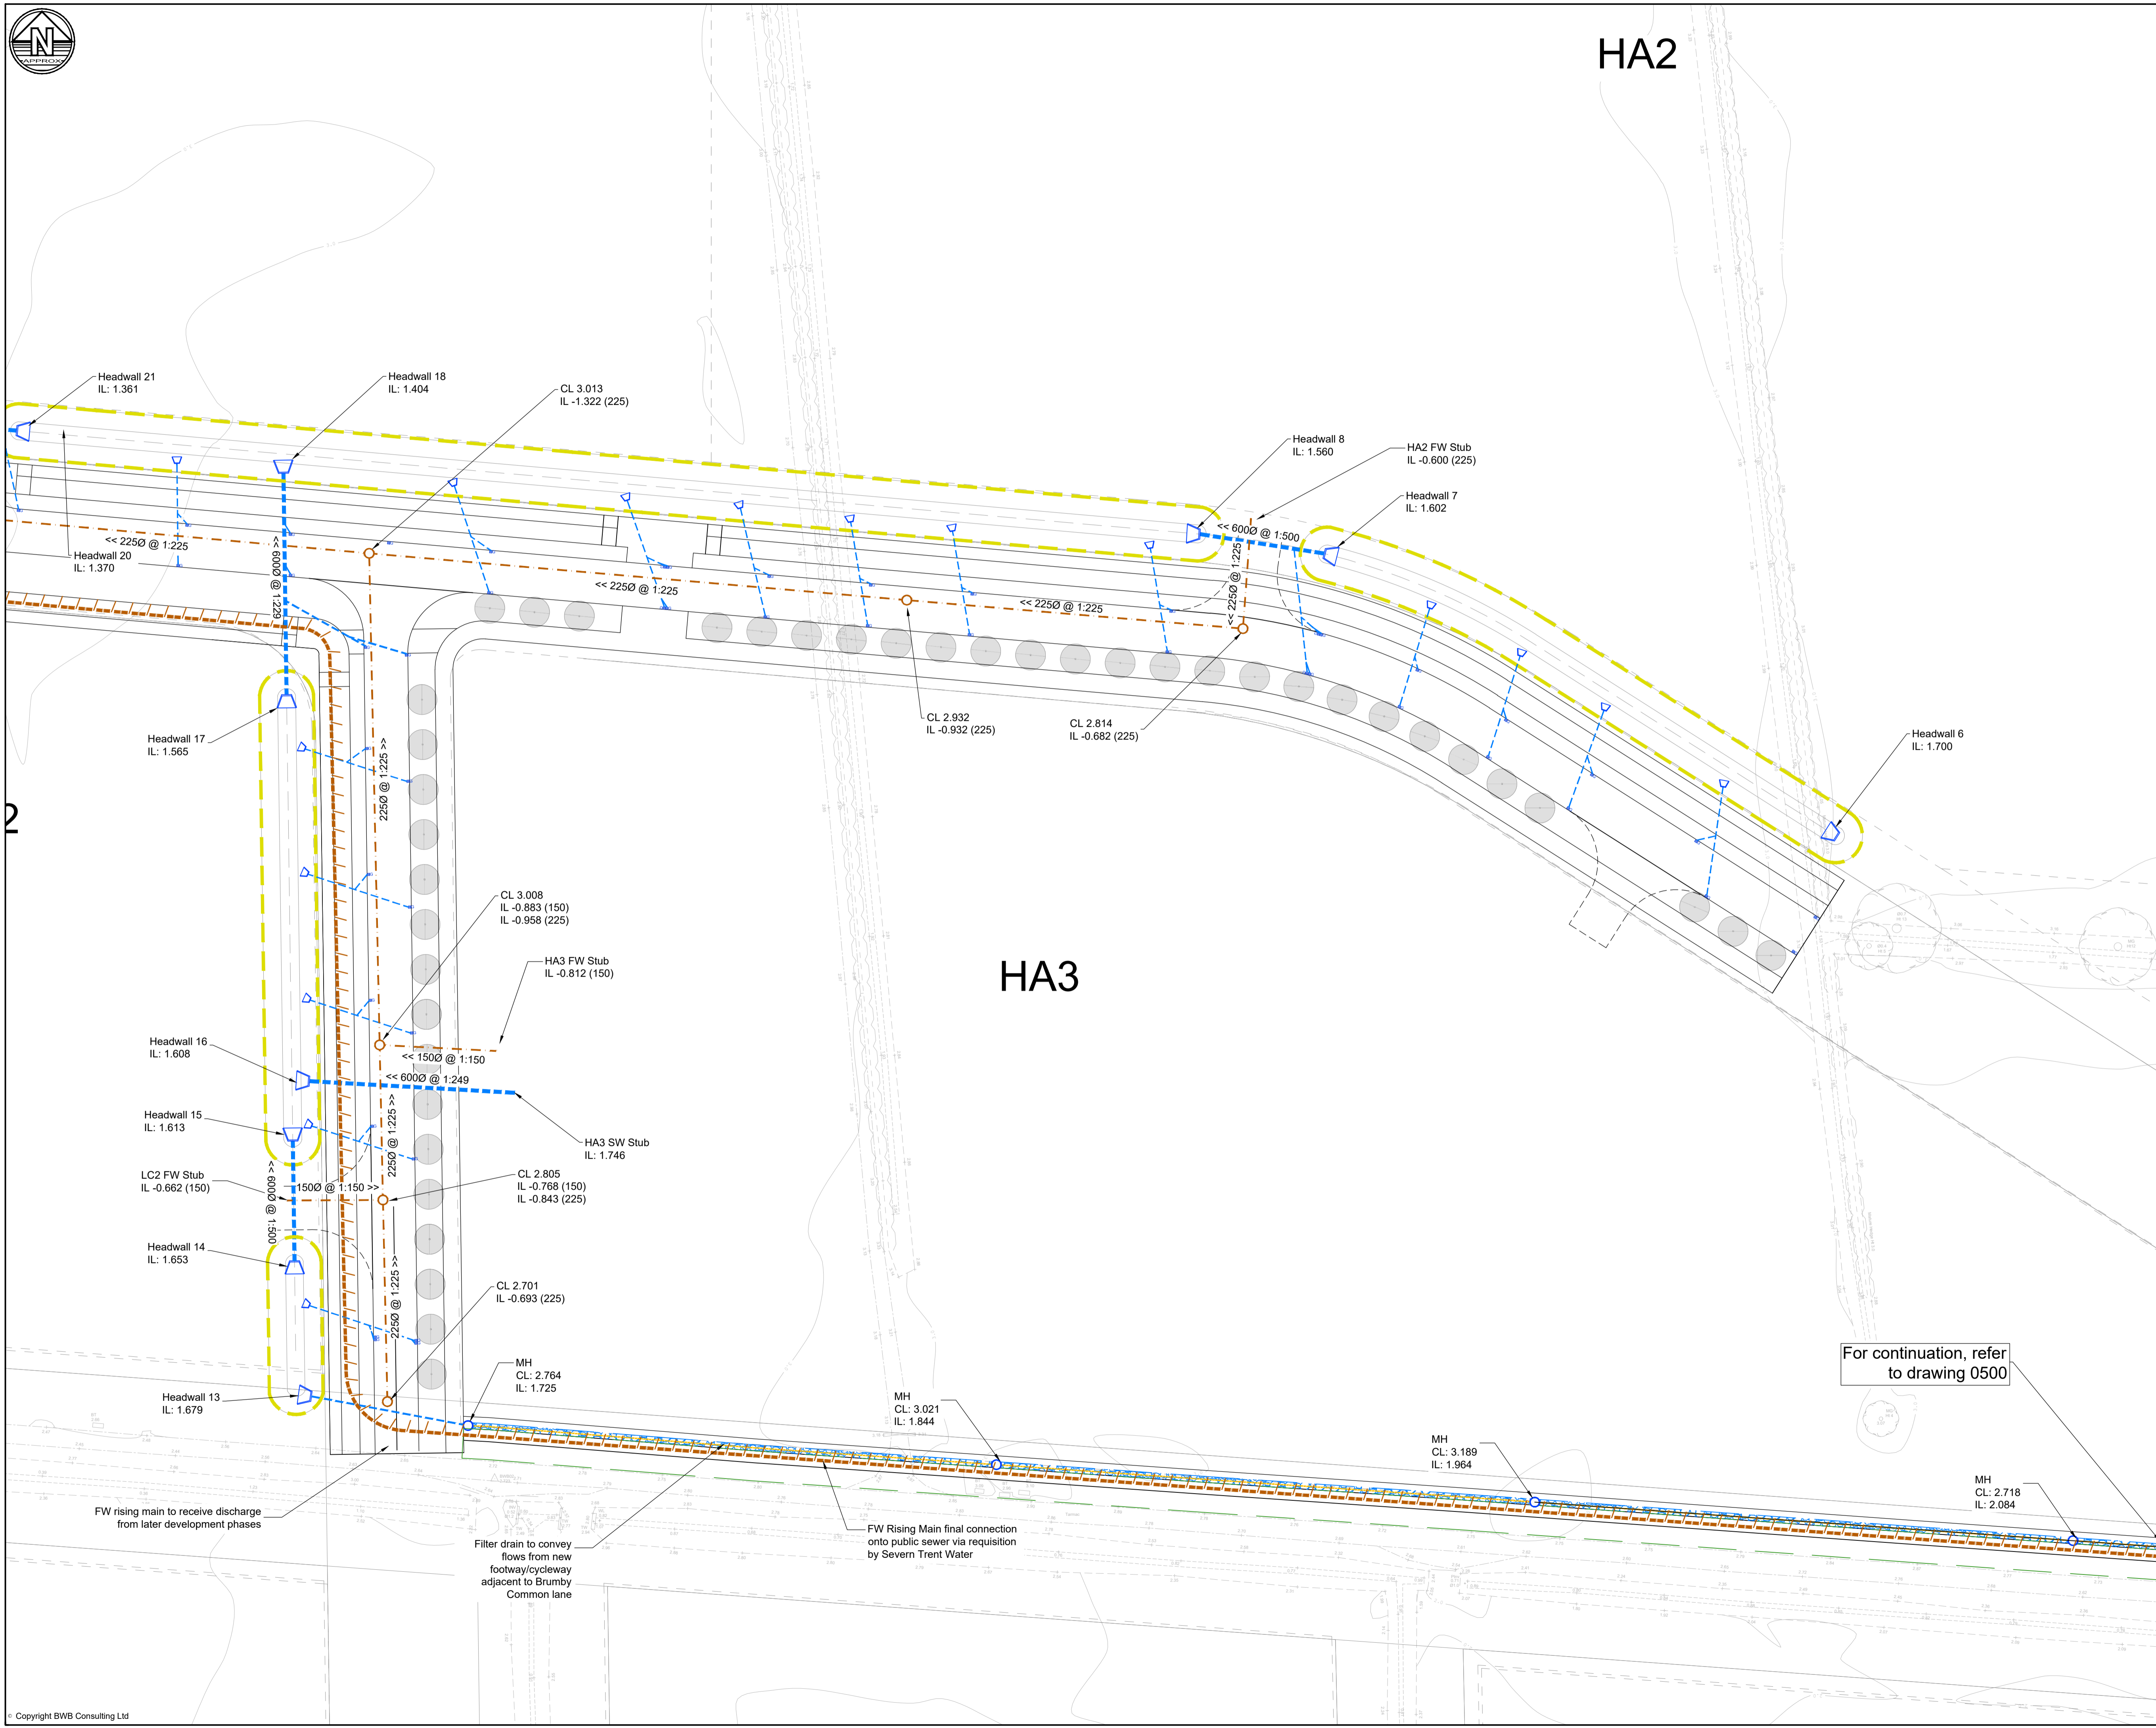


HA2

HA3



- Notes**
- Do not scale this drawing. All dimensions must be checked/ verified on site. If in doubt ask.
 - This drawing is to be read in conjunction with all relevant architects, engineers and specialists drawings and specifications.
 - All dimensions in millimetres unless noted otherwise. All levels in metres unless noted otherwise.
 - Any discrepancies noted on site are to be reported to the engineer immediately.
 - Any Surface Water Drainage pipes not specified are to be assumed as 150mm diameter.
 - Refer to BWB Drawing:
LIN-BWB-CIV-XX-DR-C-0500
LIN-BWB-CIV-XX-DR-C-0501

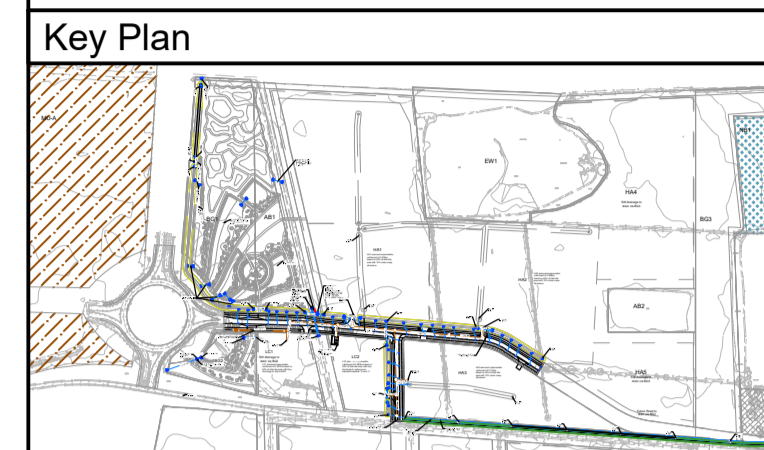

- Legend**
- Proposed Surface Water Drainage
 - Proposed Watercourse Extents
 - Filter Drain
 - Gully
 - Surface Water Headwall
 - Proposed Foul Sewer Drainage
 - Foul Sewer Drainage to be constructed as part of future phased works
 - Foul Sewer Rising Main (Final connection to be defined by Severn Trent Water)

PO2	24.12.24	Planning Issue	AB	CB
For details of previous issue / revisions, refer to revision P01				
Rev	Date	Details of issue / revision	Draw	Rev

Issues & Revisions

BWB
A CAF GROUP COMPANY

- Birmingham | 0121 233 3322
- Leeds | 0113 233 8000
- London | 020 7407 3879
- Manchester | 0161 233 4260
- Nottingham | 0115 924 1100
- www.bwbconsulting.com

Client
Hargreaves Land Ltd.

Project Title
Lincolnshire Lakes, Scunthorpe

Drawing Title
Detailed Infrastructure Drainage Layout

Sheet 2

Drawn:	A. Biag	Reviewed:	C. Brackley
BWB Ref:	221638	Date:	Dec '24
Scale@A1:	1:250	Status:	S8
Project - Originator - Zone - Level - Type - Role - Number	LIN-BWB-CIV-XX-DR-C-0502		
Rev	P02		