
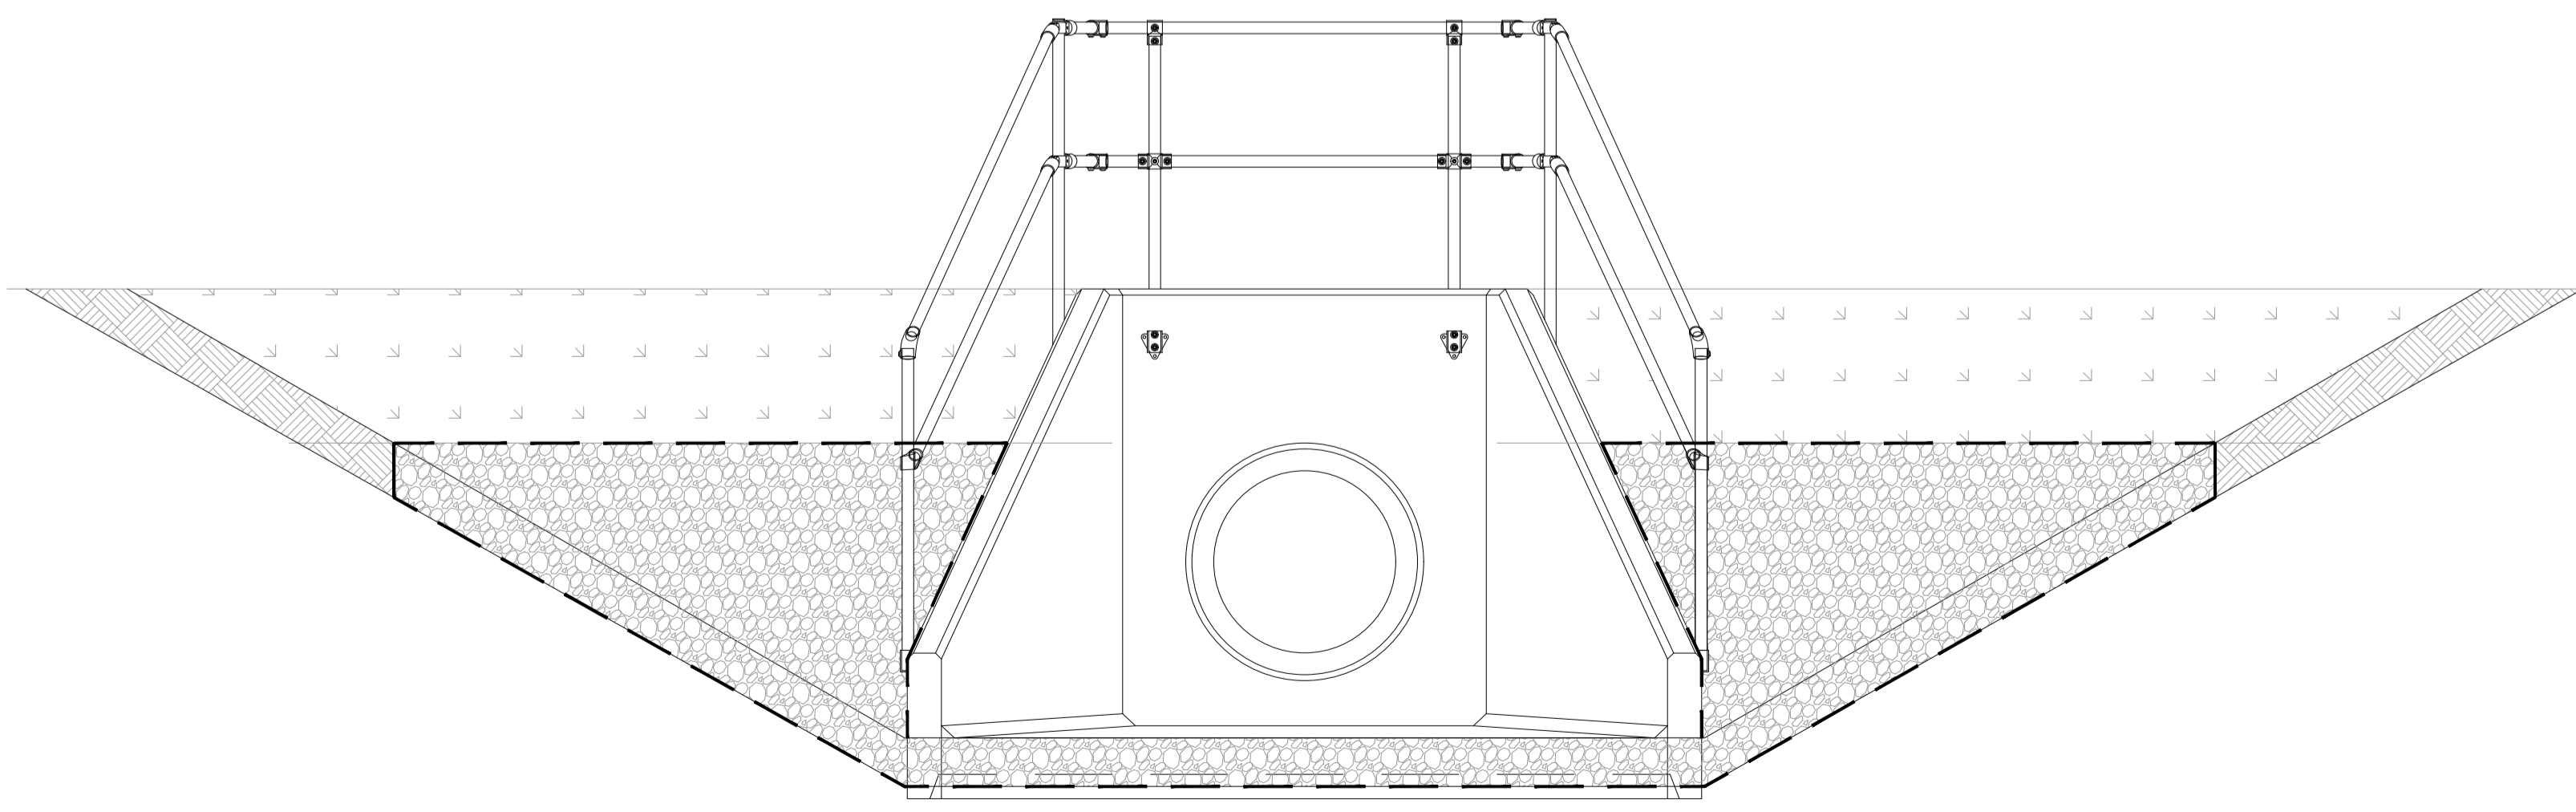


WATER AUTHORITY WARNING NOTES

- Warning signs are to be 40mm high red lettering on a white plastic base. The plastic base dimensions are to be approx. 300mm x 300mm x 6mm.
- The base is to be resistant to attack by sewage environment.
- The warning sign is to be mounted on a removable safety grid available from cover manufacturer.
- The sign in this manhole must read "Caution - Vortex Control located here".
- A sign must be fitted in the upstream MH to read "Caution - Vortex Control down stream".
- A sign must be fitted in the downstream stream MH to read "Caution - Vortex Control up stream".

TYPICAL VORTEX CONTROL CHAMBER (SCALE 1:20)

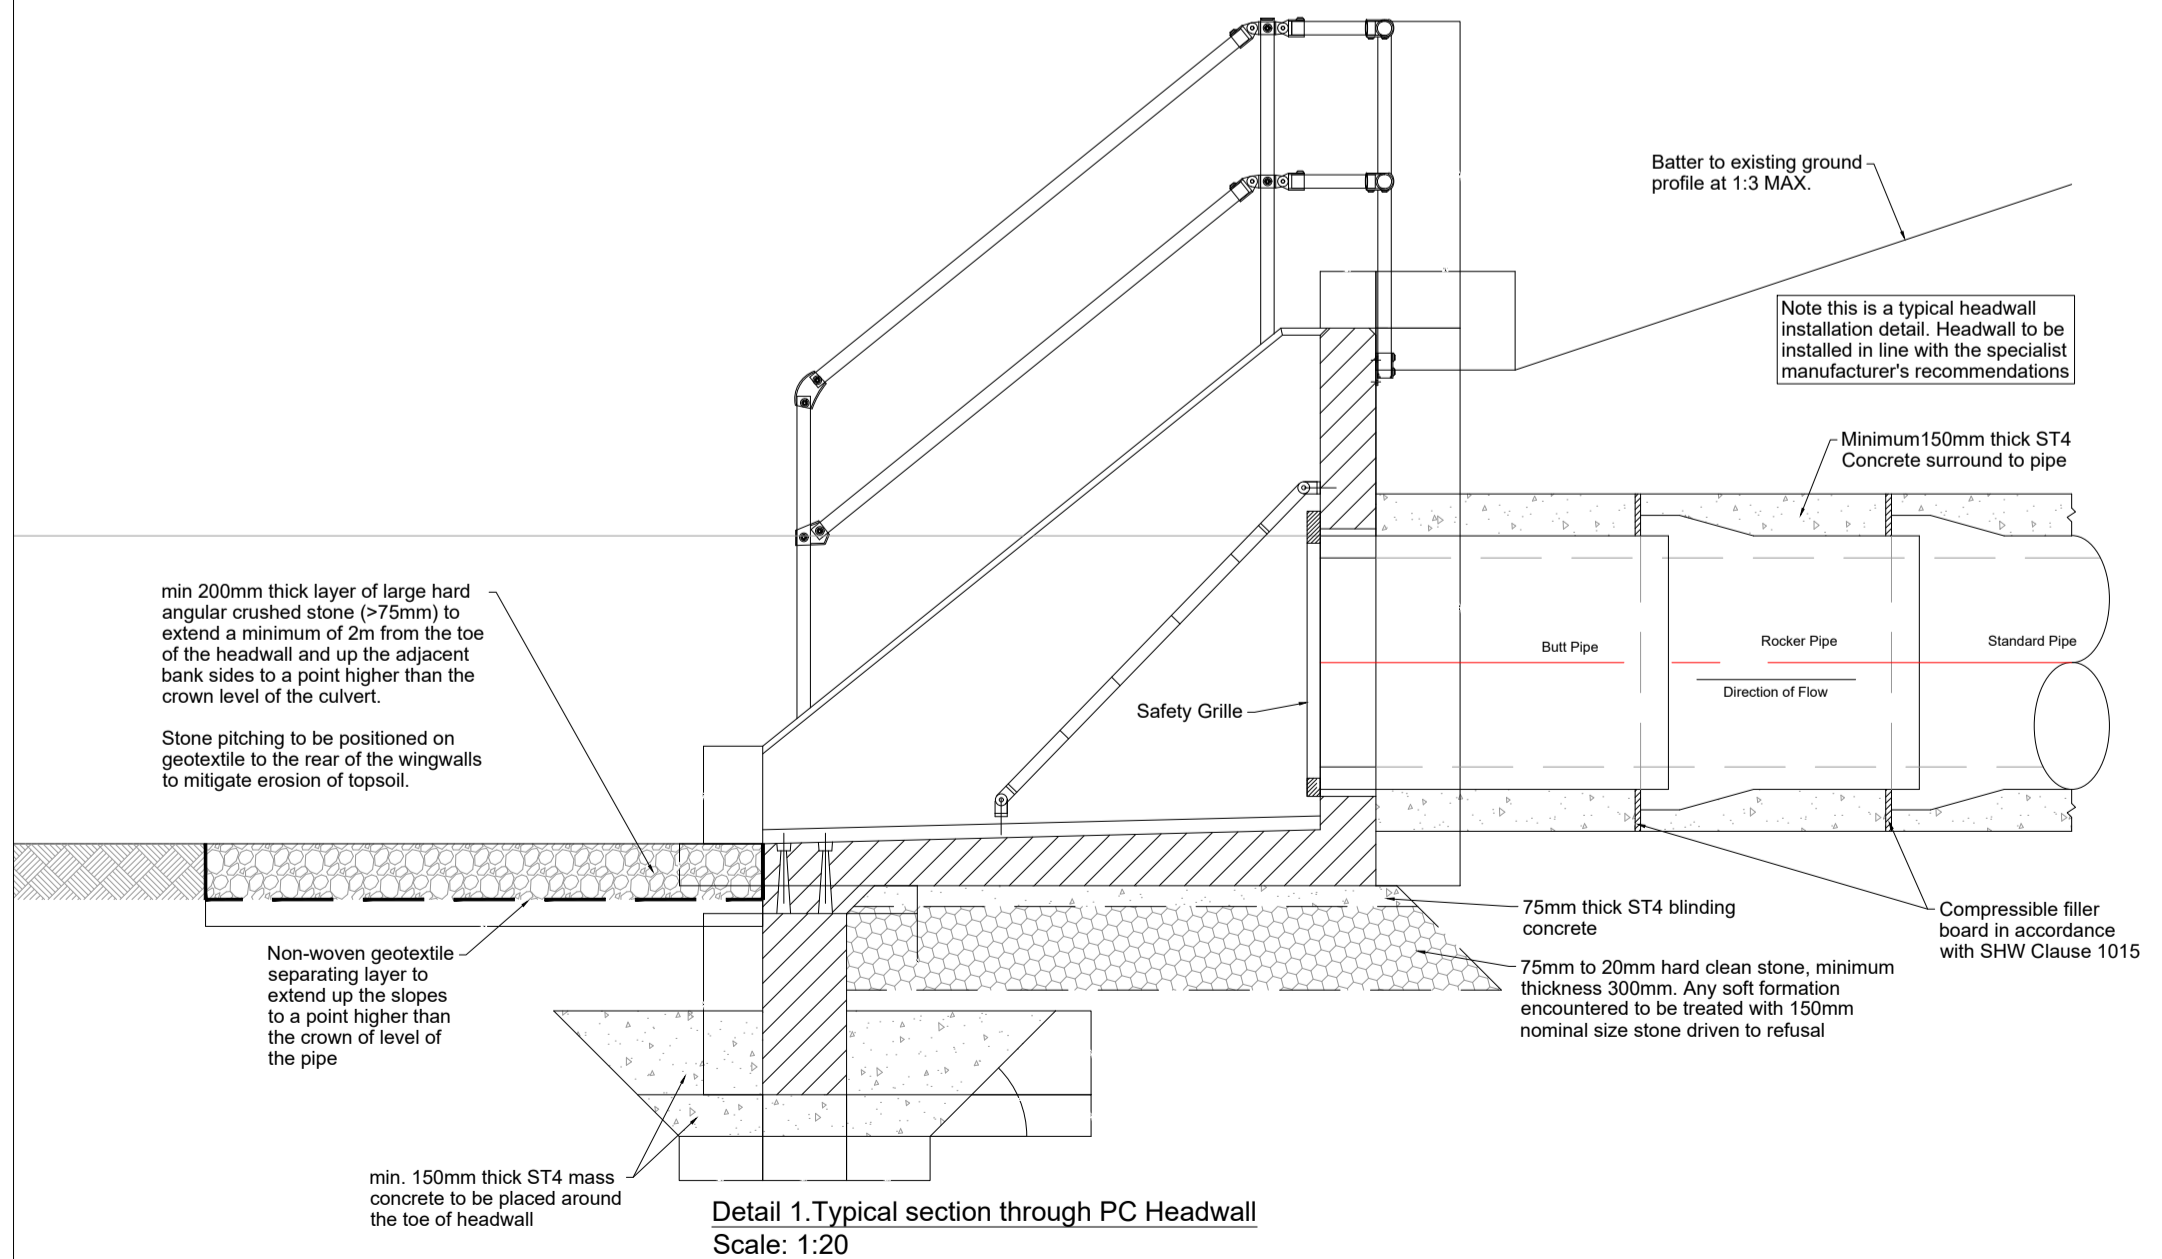

Notes

- Do not scale this drawing. All dimensions must be checked/ verified on site. If in doubt ask.
- This drawing is to be read in conjunction with all relevant architects, engineers and specialists drawings and specifications.
- All dimensions in millimetres unless noted otherwise. All levels in metres unless noted otherwise.
- Any discrepancies noted on site are to be reported to the engineer immediately.
- This drawing is to be read in conjunction with the latest drainage layout drawing.
- Unless noted otherwise, all clauses relate to Sewer Sector Guidance Notes or Building Regulations Part H.
- To be read in conjunction with BWB drawing LIN-BWB-CIV-XX-D-G-0500_Outline Drainage Strategy LIN-BWB-DDG-XX-DR-D-0560_Drainage Outfall Detail LIN-BWB-DDG-XX-DR-D-0561_Drainage Standard Details Sheet 1 LIN-BWB-DDG-XX-DR-D-0562_Drainage Standard Details Sheet 2

P01	21.01.25	Planning Issue	US	KMJ
Rev	Date	Details of issue / revision	Drw	Rev

Issues & Revisions

BWB
A CAF GROUP COMPANY

- Birmingham | 0121 233 3322
- Leeds | 0113 233 8000
- London | 020 7407 3879
- Manchester | 0161 233 4260
- Nottingham | 0115 924 1100

www.bwbconsulting.com

Client
Hargreaves Land Ltd.

Project Title
Lincolnshire Lakes, Scunthorpe

Drawing Title
Drainage Standard Details Sheet 3

Drawn:	U. Shahzad	Reviewed:	K. Jones
BWB Ref:	221638	Date:	Jan '25
Scale:	A1:	NTS	

For Planning

Project - Originator - Zone - Level - Type - Role - Number	Status	Rev
LIN-BWB-DDG-XX-DR-D-0563	S8	P01