


NOTE:
POWER ROUTE TO BE CONFIRMED
FOLLOWING ELECTRICAL DESIGN BY OTHERS

PROPOSED ARQIVA (ANGLIAN WATER) 1No. LDF4-50 & 2No. CNT400
FEEDERS TO BE INSTALLED. EXISTING AND PROPOSED CABLE
MANAGEMENT TO BE UTILIZED FOR PROPOSED UPGRADE

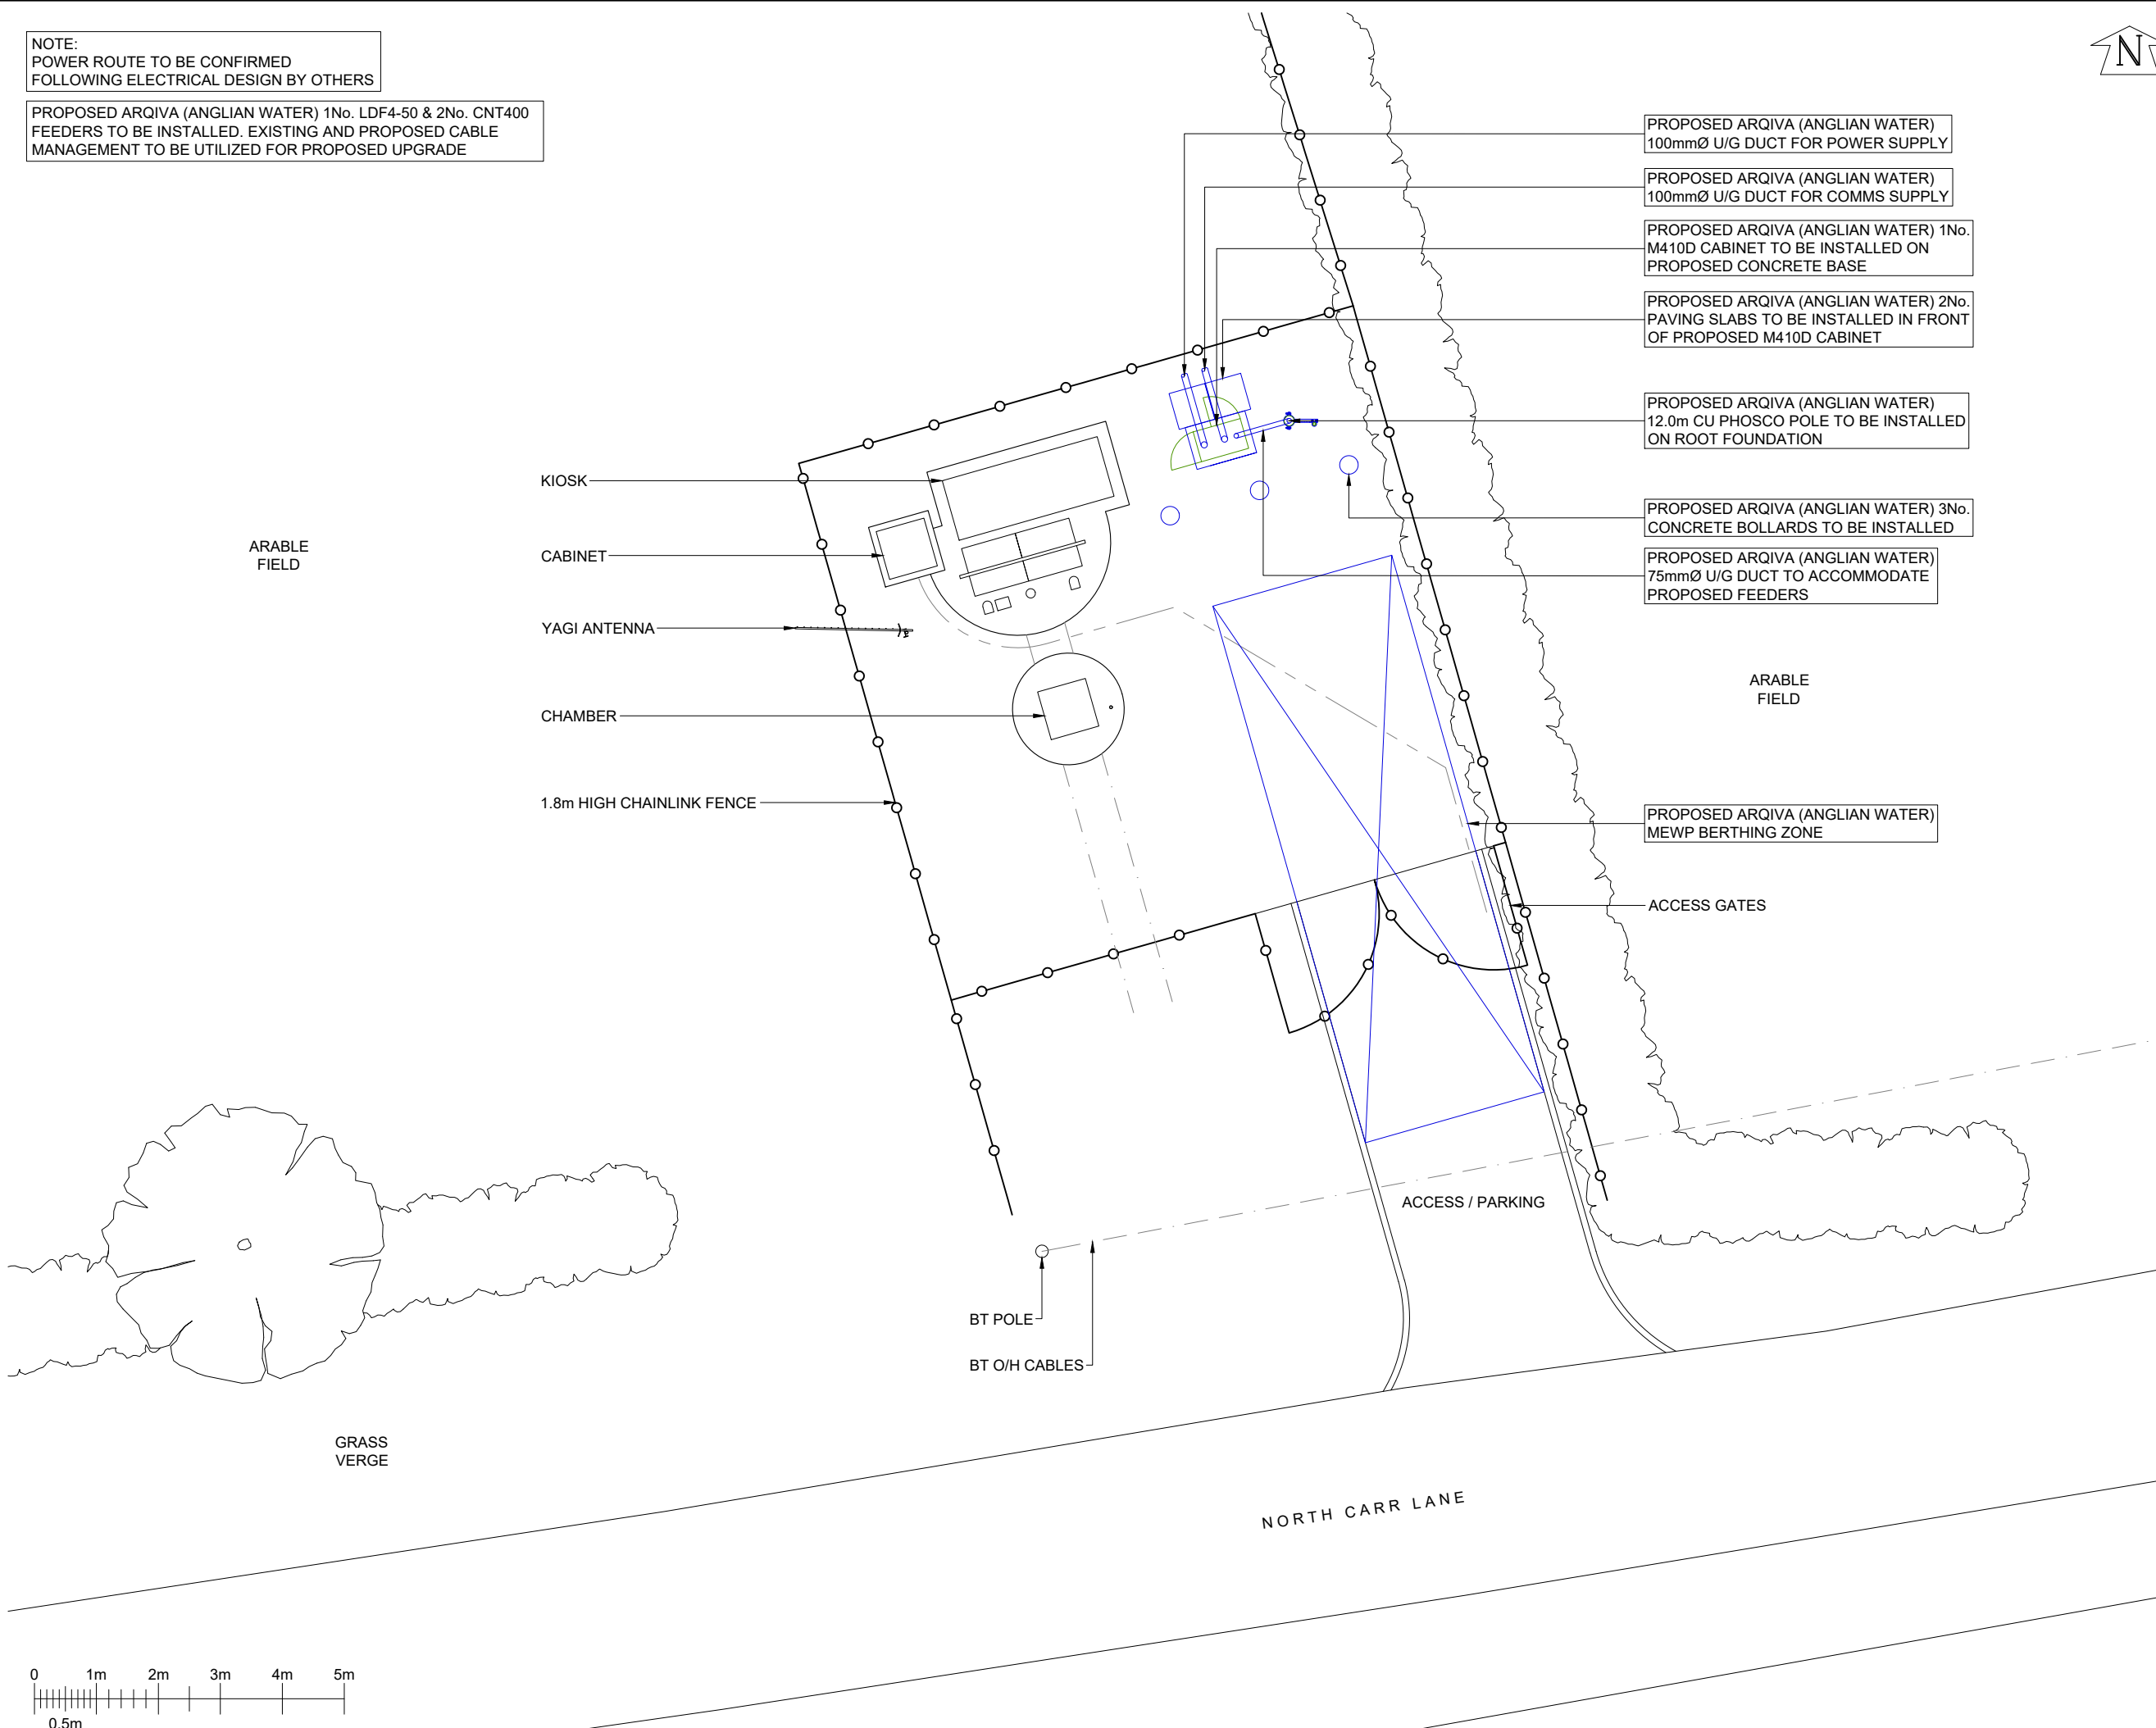

PROPOSED ARQIVA (ANGLIAN WATER)
100mmØ U/G DUCT FOR POWER SUPPLY

PROPOSED ARQIVA (ANGLIAN WATER)
100mmØ U/G DUCT FOR COMMS SUPPLY

PROPOSED ARQIVA (ANGLIAN WATER) 1No.
M410D CABINET TO BE INSTALLED ON
PROPOSED CONCRETE BASE

PROPOSED ARQIVA (ANGLIAN WATER) 2No.
PAVING SLABS TO BE INSTALLED IN FRONT
OF PROPOSED M410D CABINET

PROPOSED ARQIVA (ANGLIAN WATER)
12.0m CU PHOSCO POLE TO BE INSTALLED
ON ROOT FOUNDATION

PROPOSED ARQIVA (ANGLIAN WATER) 3No.
CONCRETE BOLLARDS TO BE INSTALLED

PROPOSED ARQIVA (ANGLIAN WATER)
75mmØ U/G DUCT TO ACCOMMODATE
PROPOSED FEEDERS

PROPOSED ARQIVA (ANGLIAN WATER)
MEWP BERTHING ZONE

© Arqiva
All rights reserved. No part of this publication may be reproduced, stored
in a retrieval system or transmitted in any form or by any means
(Electronic, Mechanical, Photocopying, Recording or otherwise), without
the prior written consent of the Company.

NOTES
OTHER USERS PROPOSALS
FEINT DETAILS SHOWN AS
ARE INDICATIVE OF OTHER USERS
PROPOSALS WHICH MAY BE THE
SUBJECT OF SEPARATE
APPLICATIONS

PROJECT: ANW_DN130

ISS	REVISION	DATE	DRN	APP
2	PROJECT: 12263977 PLANNING	23/07/25	HFC	HFC
1	PROJECT: 12263977 SITE RECORD	15/07/25	KML	DH

Crawley Court, Winchester, Hampshire, SO21 2QA
cad.services@arqiva.com

SITE No. 325124
SAXBY BRIDGE LANE SP
BRIDGE LANE
SAXBY
BRIGG
LINCOLNSHIRE
DN20 0QQ

NGR SE 98816 16955
OS GRID 498816 416955

TITLE
SITE PLAN
PROPOSED
ARQIVA (ANGLIAN WATER)

SCALE 1:100
DRAWN KML 14/07/25
APPROVED HFC 23/07/25

DRAWING No. SHEET 1 OF 1 REV.
325124-01-100-MD002 2