



Ordnance Survey, (c) Crown Copyright 2024. All rights reserved. Licence number 100022432

Location Plan
scale 1:1250

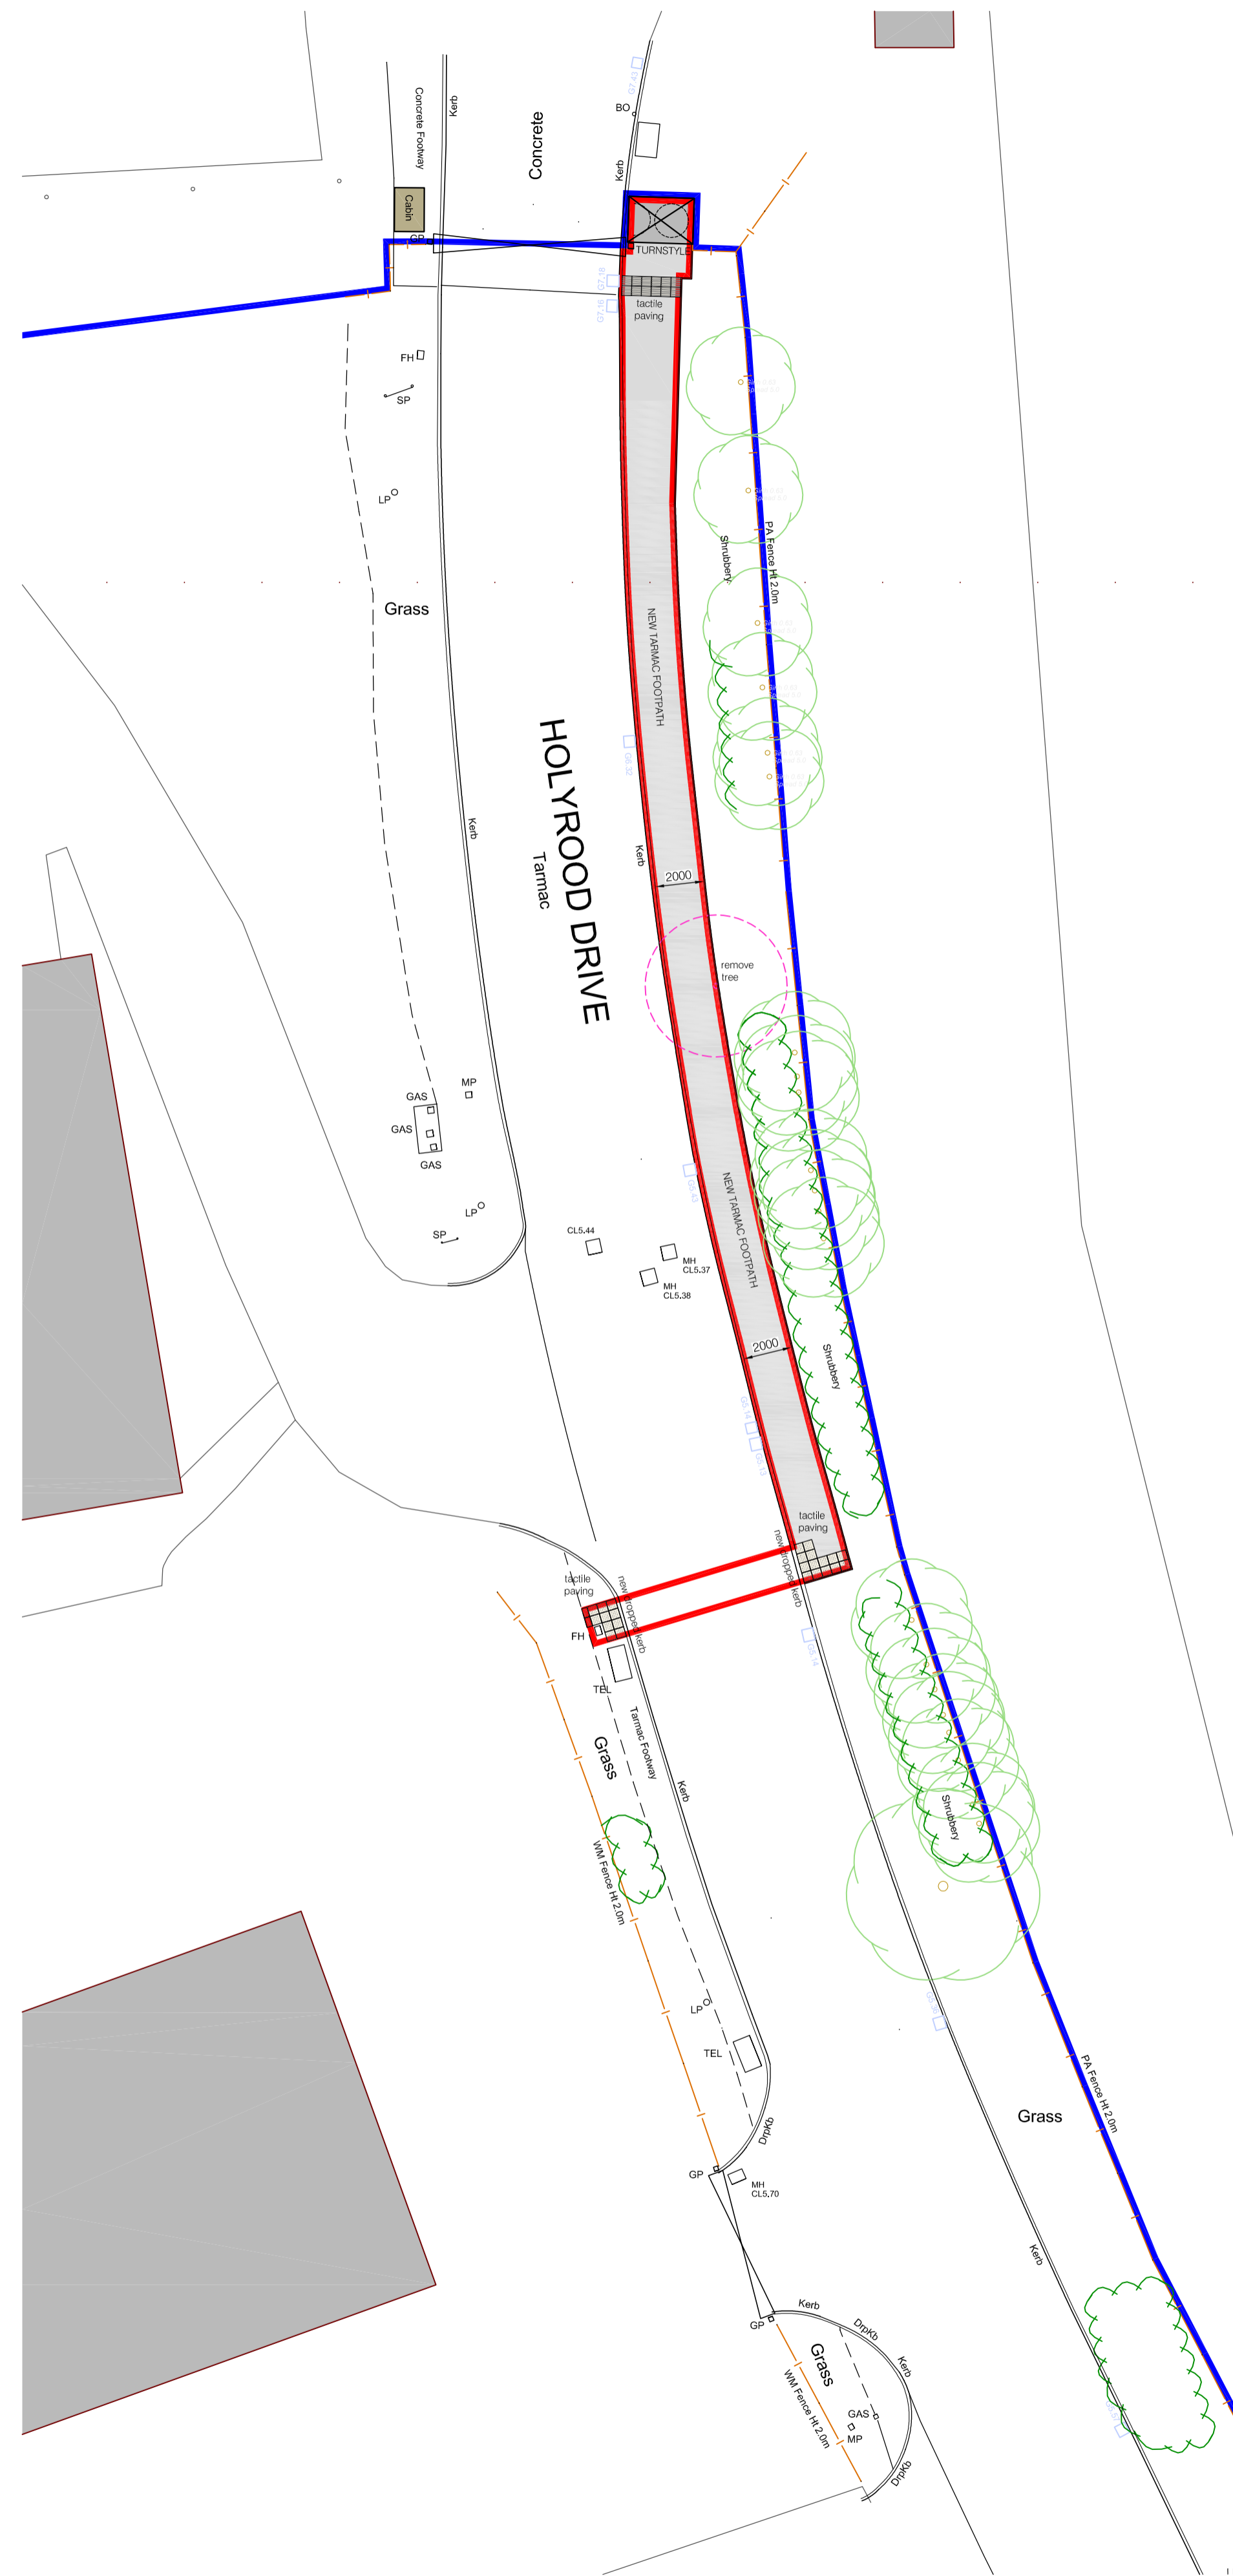

Proposed Site Layout
scale 1:200

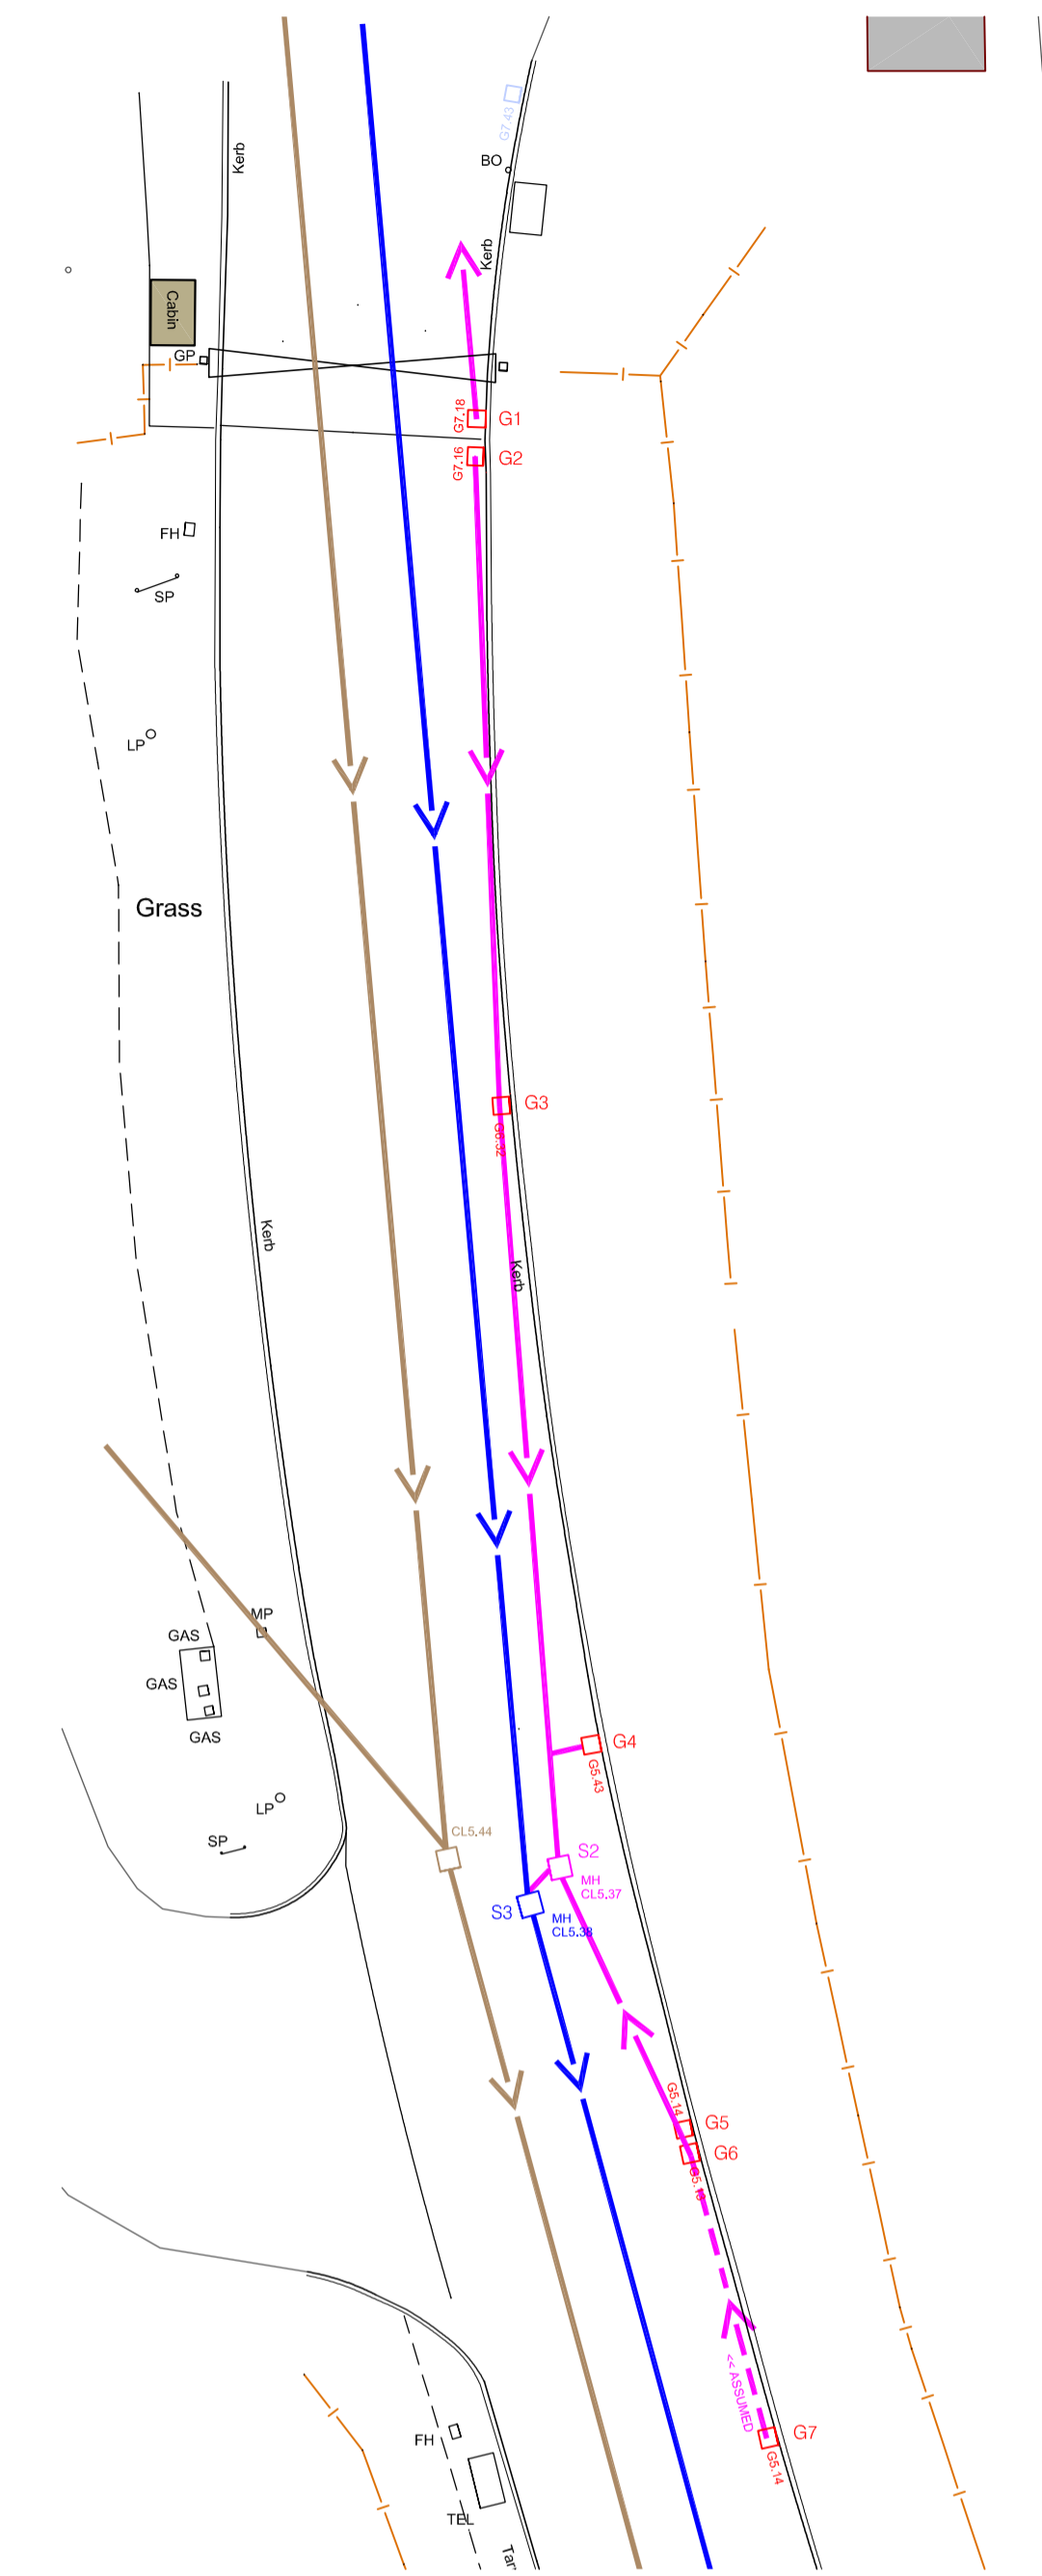

Drainage Layout
scale 1:200

NOTES:

All dimensions & details given on this drawing are to be checked and verified on site prior to works being undertaken. Any discrepancies and/or variations to the specifications within these drawings or associated documents are to be notified to keystonearchitecture.

Do not scale from these drawings - if in doubt - ask.

All materials shall be fixed, applied or mixed in accordance with the manufacturers written instructions, recommendations and specifications. Variations to specified materials shall be agreed in writing with keystone architecture.

The Contractor shall take into account everything necessary for the proper execution of the works and to the satisfaction of the Local Authority, whether or not indicated on the drawings or in the specification.

This drawing is the copyright of keystone architecture and must not be reproduced without written consent. © keystone architecture 2025

PLANNING DRAWING ONLY

rev	amendment	date	dwg. no.	1964.01 rev A
A	Drainage Layout Added	27/01/26		

title	Ex. & Pr. Plans	dwg. no.	1964.01 rev A
New Footpath & Turnstyle at CanPack UK	Planning	drawn by	JCB
Holyrood Drive	stage	drawn by	JCB
Scourthorpe	scale	drawn by	JCB